



FIFTH FLOOR FAR AREA CALCULATIONS					
NO.	COEFF.	BREADTH	LENGTH	NO.s	AREA (SQ.M)
ADDITION					
1	1	4.000	10.220	1	40.880
2	1	47.815	14.620	1	699.055
3	4.770+6.185/2	7.365	1	40.342	
4	6.185+8.355/2	2.795	1	20.320	
5	8.355+9.245/2	5.355	1	47.124	
6	9.245+10.985/2	3.625	1	36.667	
7	10.985+11.145/2	2.060	1	22.794	
8	11.145+13.470/2	5.370	1	66.091	
9	13.470+1.540/2	20.075	1	150.663	
10	0.667	24.355	5.655	1	91.864
11	0.5	0.860	0.510	1	0.219
TOTAL AREA (A1)					1216.019
DEDUCTION					
D1	1	1.730	0.600	1	1.038
D2	1	2.610	1.850	3	14.486
D3	1	6.600	4.890	1	32.274
D4	1	5.000	0.900	1	4.500
D5	1	1.250	0.900	1	1.125
D6	1	0.985	0.600	1	0.591
D7	1	0.985	2.820	1	2.778
D8	1	0.815	1.750	1	1.426
D9	1	0.300	0.500	1	0.150
D10	1	0.600	0.800	1	0.480
D11	1	3.875	8.290	1	32.124
D12	1	1.700	0.730	1	1.241
TOTAL AREA (D)					92.212
NET FAR AREA (A-D)					1123.807

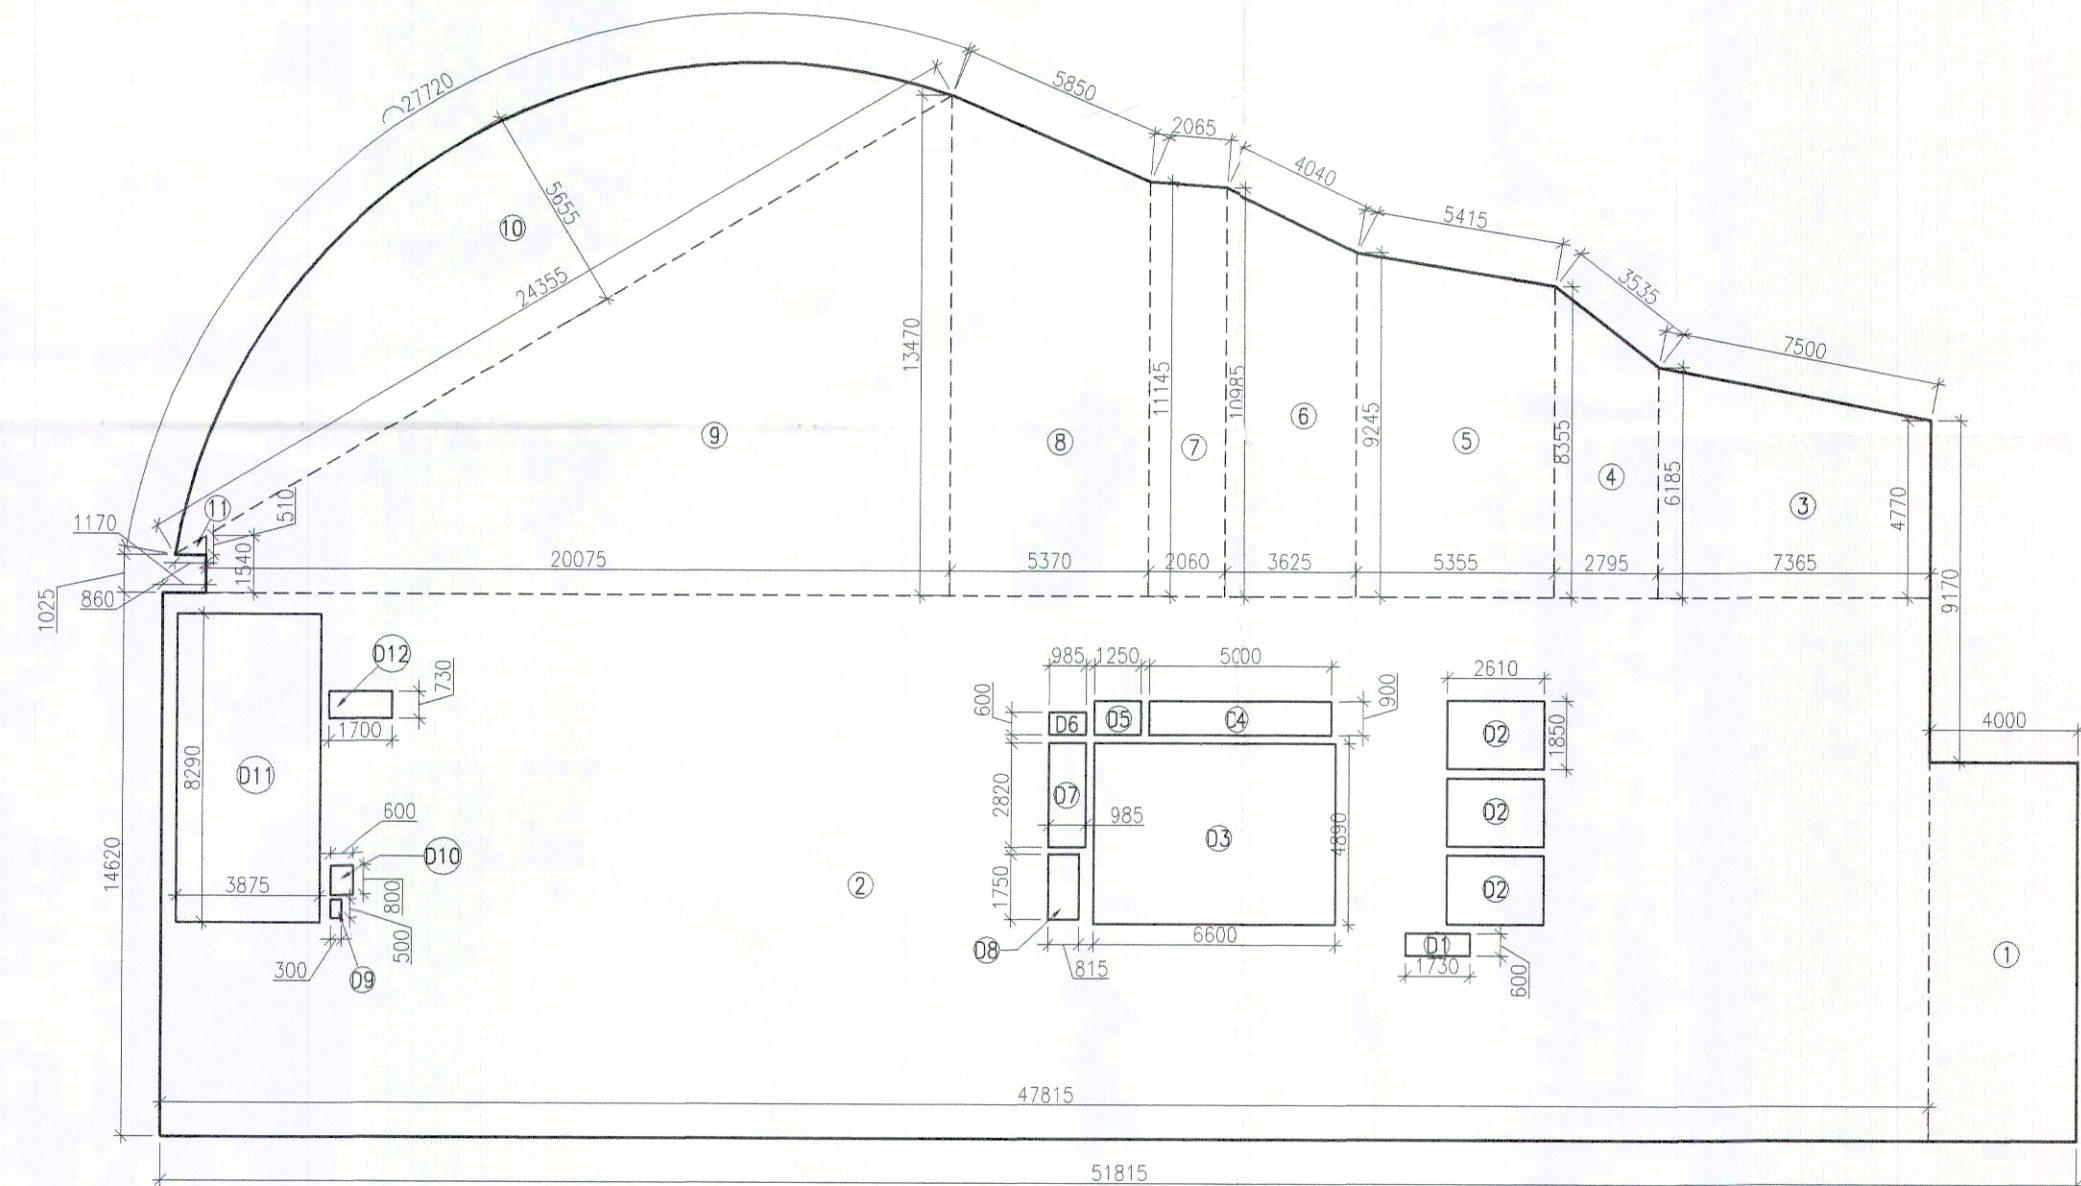

5TH FLOOR AREA DIAGRAM

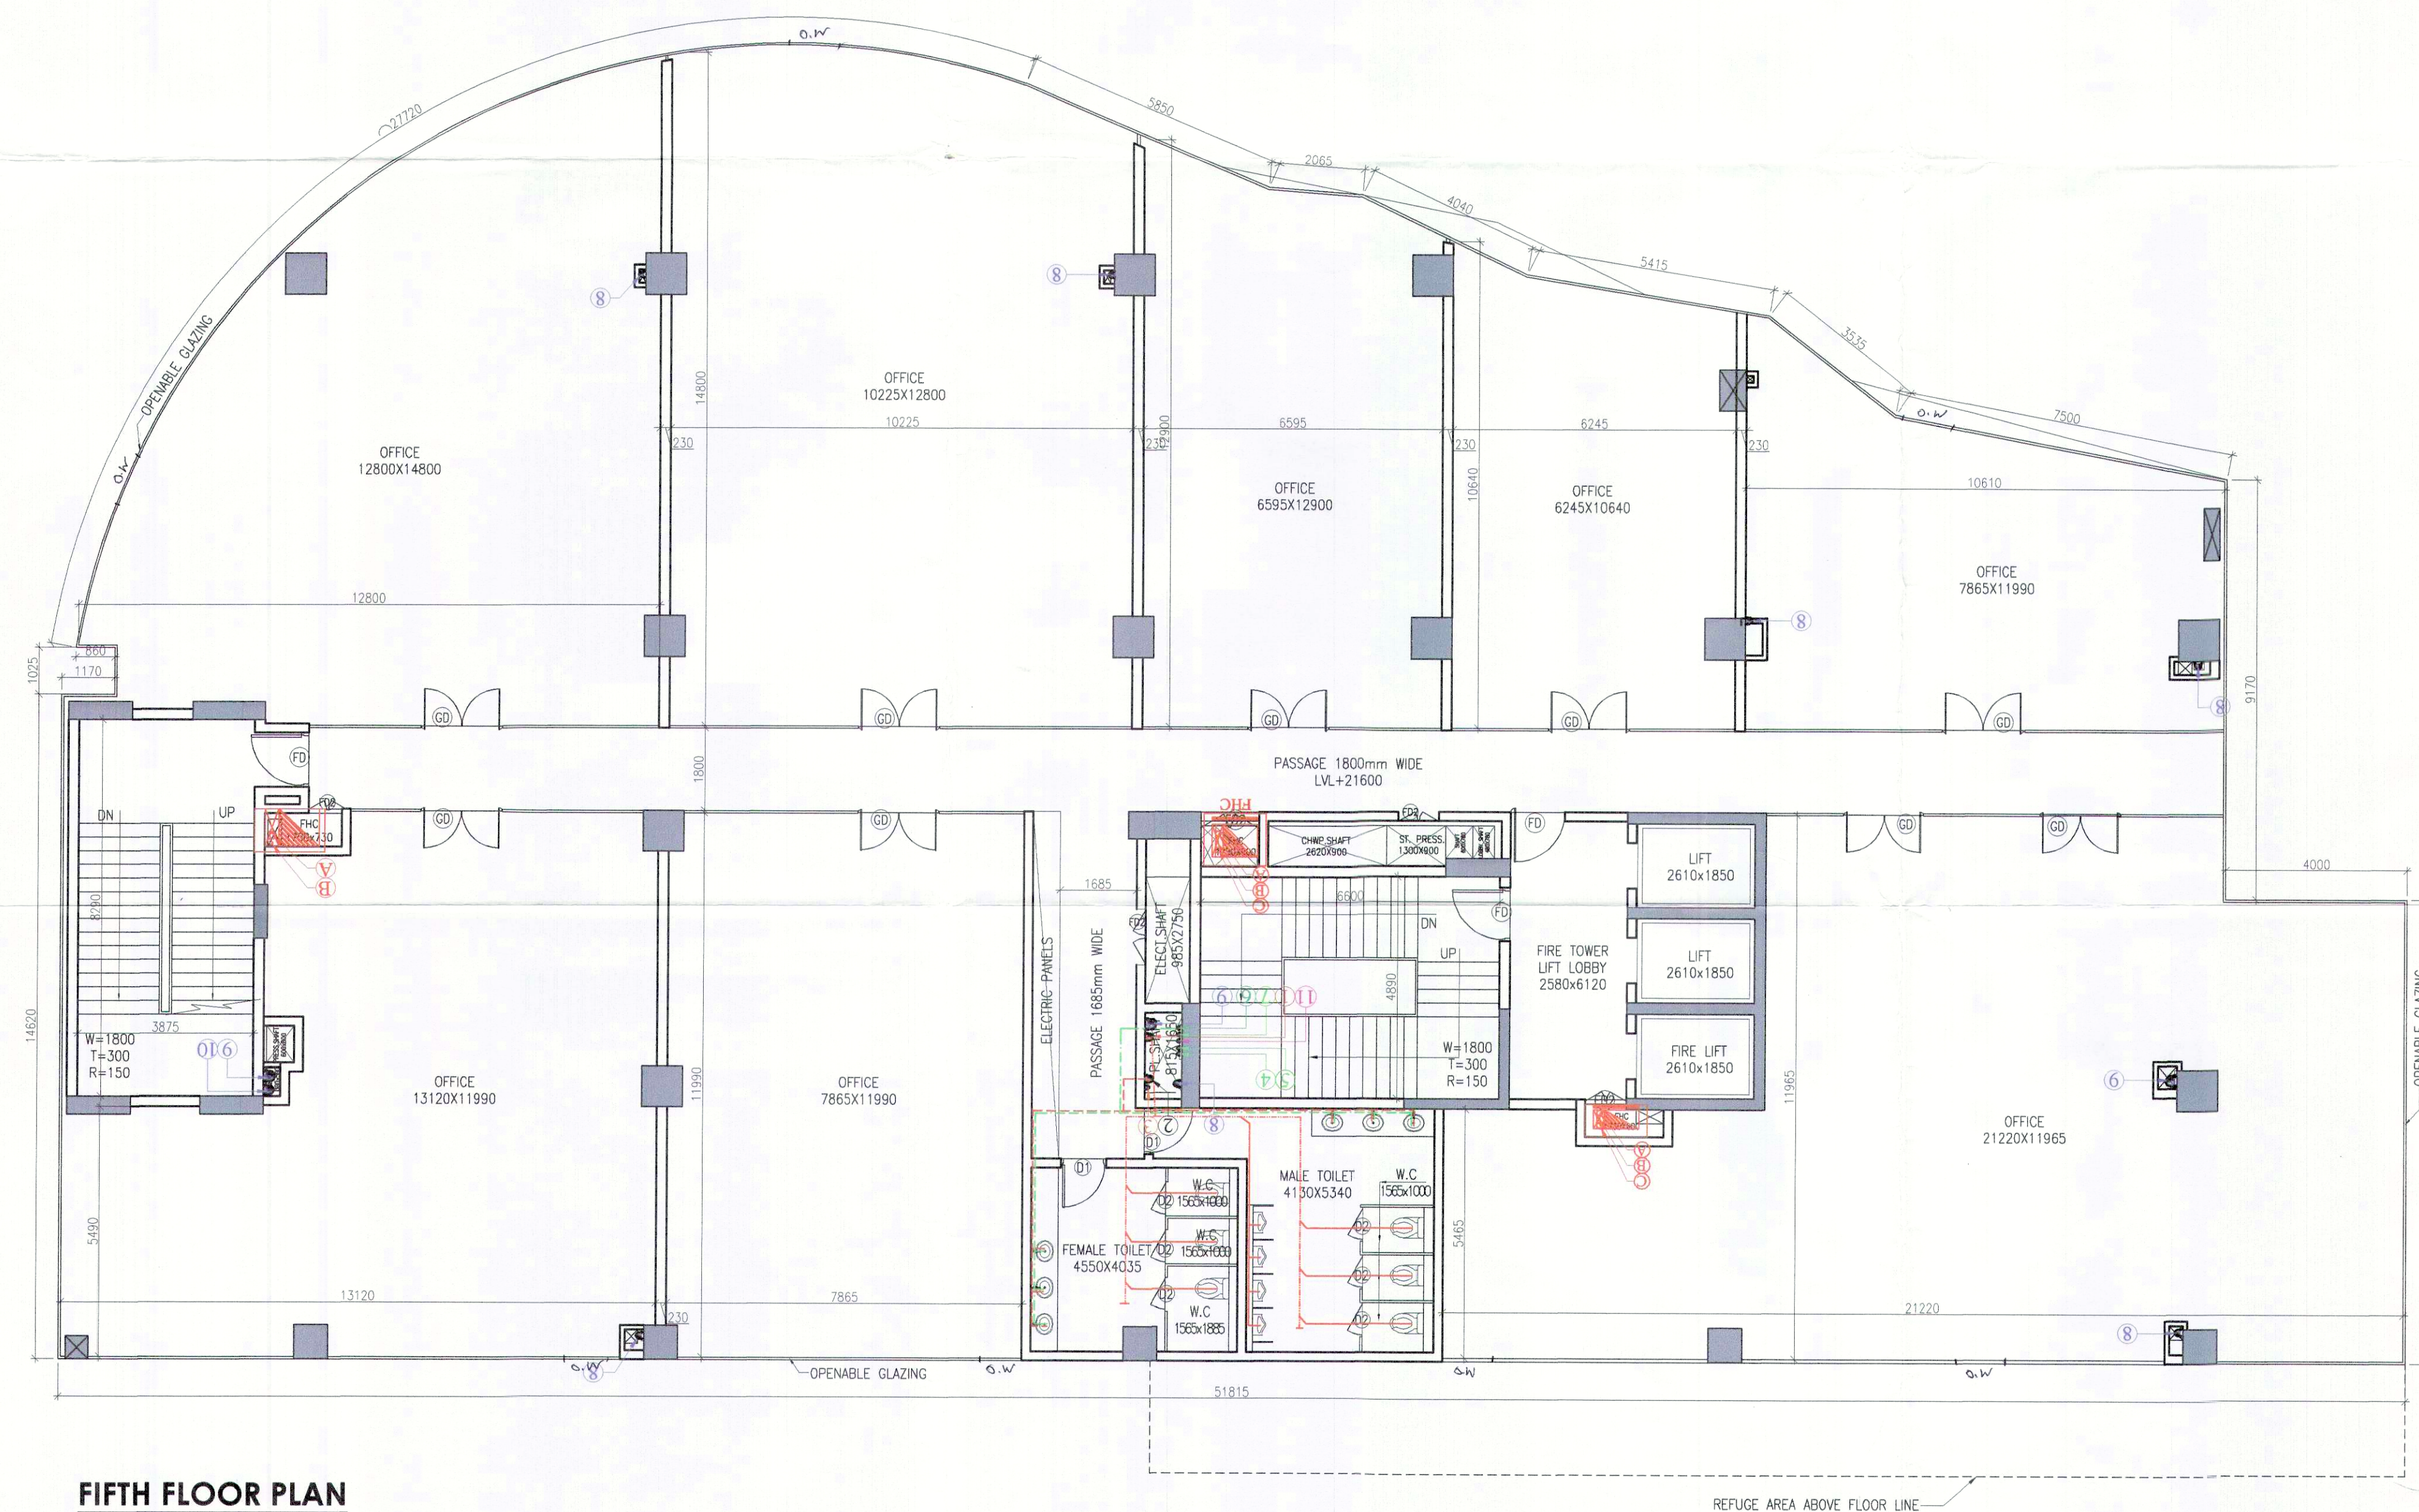

FIFTH FLOOR PLAN

This is a "PROVISIONAL BUILDING PLAN" approved only for the purpose of inviting objections from the general public.

STP(HQ) Member Secretary BPAC
STP(HQ) Member BPAC
CTP(HQ) Chairman BPAC

DD Member BPAC
DTP(HQ)
ATP(HQ)

DINESH KUMAR PA(HQ)
Checked and found ok for Public Health (Internal) Service only subject to comments in forwarding letter No. SE(HQ) 11/33/57/22

TO BE READ WITH THIS OFFICE MEMO NO.: DATED :

Superintending Engineer (HQ) for Chief Engineer 1 HSVP
Panchajanya
SDE (C)

TOILET CALCULATION				
F.A.R. AREA ON 5TH FLOOR = 1123.807 SQM.				
DENSITY ON 5TH FLOOR = 112 Nos.				
NO.	REQUIRED		PROVIDED	
	MALE (2/3)	FEMALE(1/3)	MALE (2/3)	FEMALE(1/3)
W.C.	3	2	3	3
URINAL	3	-	4	-
WASH BASIN	3	2	3	3

PLUMBING LEGEND:-				
1	110 OD UPVC SOIL PIPE			
2	110 OD UPVC WASTE PIPE			
3	50 OD WASTE PIPE (FD TO FT)			
4	40 OD WASTE PIPE(WASH BASIN TO FT)			
5	50 OD SOIL PIPE(URINAL TO UT)			
6	DOMESTIC WATER SUPPLY (DWS)			
7	FLUSHING WATER SUPPLY (FWS)			

1	110 OD UPVC SOIL PIPE
2	110 OD UPVC WASTE PIPE
3	75 OD VENT PIPE
4	DWS DN. TAKE
5	FWS DN. TAKE
6	DWS RISER
7	FWS RISER
8	110 OD UPVC RAIN WATER PIPE
9	200 OD UPVC RAIN WATER PIPE
10	160 OD UPVC RAIN WATER PIPE
11	SOFT WATER SUPPLY RISER

D	110 DRAIN PIPE
C	= PIPE DROP
FT	= FLOOR TRAP
FD	= FLOOR DRAIN
UT	= URINAL TRAP
AD	= ACCESS DOOR
COP	= CLEAN OUT PLUG
FCO	= FLOOR LEAN OUT
=	= VALVE
=	= 150X150 CUTOUT FOR FT,UT,WC
FHC	FIRE HOSE CABINET
A	150# FIRE HYDRANT PIPE
B	80# DRAIN PIPE
C	150# SPRINKLER PIPE

SCHEDULE OF OPENING					
S.R	TYPE	SIZE	S.L.	LL.	
1	GD	2400	X	2400	00
2	GD1	1200	X	2400	00
3	FD	1500	X	2400	00
4	FD1	1200	X	2400	00
5	FD2	1000	X	2400	00
6	D	1200	X	2400	00
7	D1	1050	X	2400	00
8	D2	750	X	2100	00

PROJECT
REVISED BUILDING PLAN OF COMMERCIAL COLONY MEASURING 1.6577 ACRES (LICENCE NO. 68OF 2009 DATED 19.11.2009) IN SECTOR-37 FARIDABAD BEING DEVELOPED BY M/S MPDL LTD. (FORMERLY KNOWN AS MONNET PROJECT DEVELOPER LTD.)

ARCHITECTS
SACHDEVA CONSULTANTS.
Parnami Tower, 3rd Floor, S.C.O. 50-51, Old Judicial Complex, Civil Lines, Gurgaon - 122001
Tel.: 0124-4081801, 4081802
Email : saccon1953@gmail.com

ARCHITECT'S SEAL & SIGNATURE
OWNER/AUTH. SIGNATURE

Scale : 1:100
Drawing Title:- FIFTH FLOOR PLAN
Drawing No:- RS-10