

This is a "PROVISIONAL BUILDING PLAN" approved only for the purpose of inviting objections from the general public

STR(HQ) Member Secretary BPAC
STR(F) Member BPAC
CTP(HQ) Chairman BPAC

DDP(T) MEMBER BPAC

DTP(HQ)

ATP(HQ)


DINESH KUMAR PA(HQ)

Checked and found ok for Public Health (Internal) Service only subject to comments in forwarding letter No. SE(HQ)/.../57/122.

Superintending Engineer (HQ) for Chief Engineer 1 HSVP
SDEW


TO BE READ WITH THIS OFFICE MEMO NO.: DATED :

7TH FLOOR FAR AREA CALCULATIONS					
NO.	COEFF.	BREADTH	LENGTH	NO.s	AREA (SQ.M)
ADDITION					
1	1	2.085	7.605	1	15.856
2	1	10.410	2.925	1	30.449
3	1	2.030	0.800	1	1.624
4	1	24.100	2.925	1	70.493
5	1	47.815	9.080	1	434.160
6	4.770+7.325/2	9.805	1	59.296	
7	7.325+10.385/2	6.365	1	56.362	
8	10.385+11.780/2	6.915	1	76.635	
9	11.780+13.470/2	3.490	1	44.061	
10	13.470+15.40/2	20.075	1	150.663	
11	0.667	24.355	5.655	1	91.864
12	0.5	0.860	0.510	1	0.219
TOTAL AREA (A1)					1031.683
DEDUCTION					
D1	1	1.615	0.600	1	0.969
D2	1	2.610	1.850	3	14.486
D3	1	6.600	4.890	1	32.274
D4	1	5.000	0.900	1	4.500
D5	1	1.250	0.900	1	1.125
D6	1	0.985	0.600	1	0.591
D7	1	0.985	2.820	1	2.778
D8	1	0.815	1.750	1	1.426
D9	1	0.300	0.500	1	0.150
D10	1	0.600	0.800	1	0.480
D11	1	3.875	8.290	1	32.124
D12	1	1.700	0.730	1	1.241
TOTAL AREA (D)					92.143
NET FAR AREA (A-D)					939.540

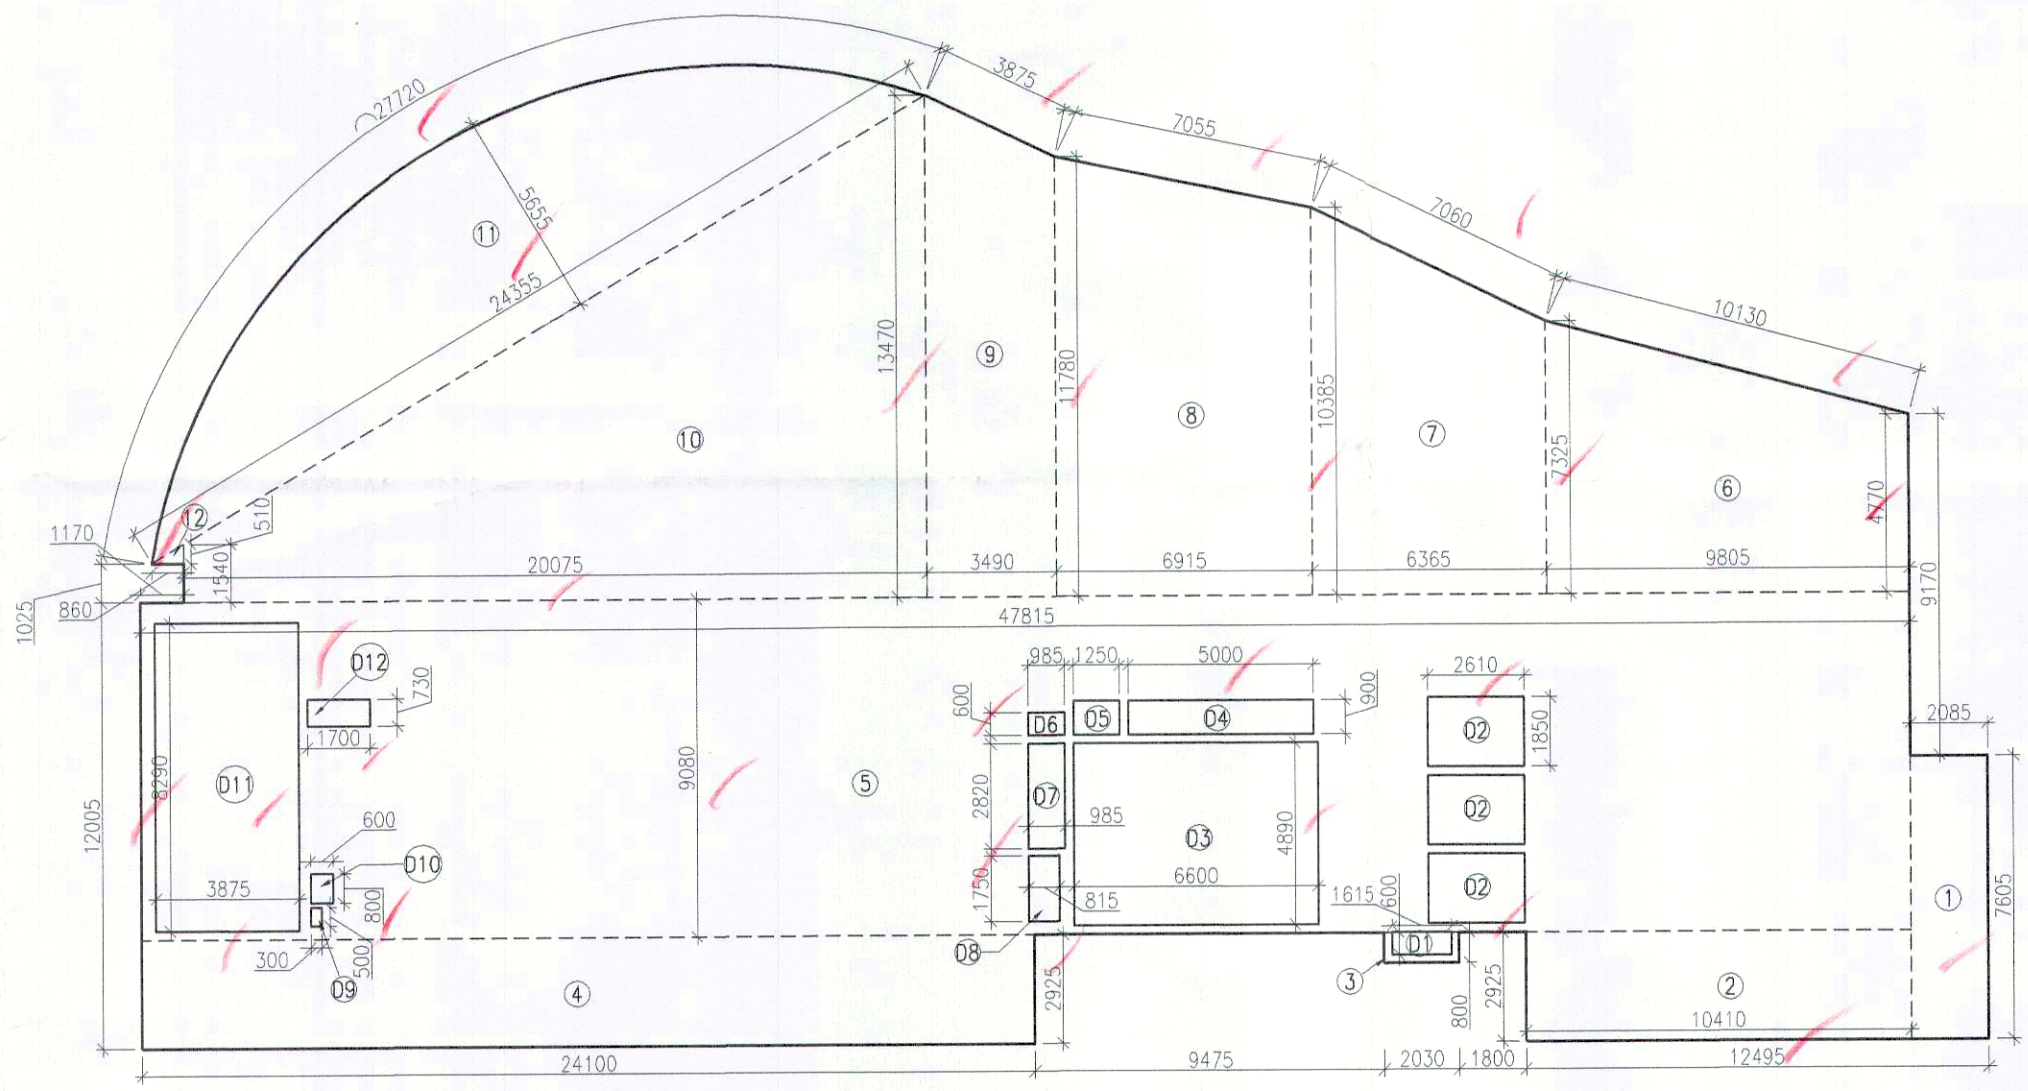

7TH FLOOR AREA DIAGRAM

TOILET CALCULATION				
F.A.R. AREA ON 7TH FLOOR = 939.540 SQM.				
DENSITY ON 7TH FLOOR = 94 Nos.				
REQUIRED			PROVIDED	
NO.	MALE (2/3)	FEMALE(1/3)	MALE (2/3)	FEMALE(1/3)
W.C.	3	1	4	3
URINAL	3	-	4	-
WASH BASIN	3	1	3	3

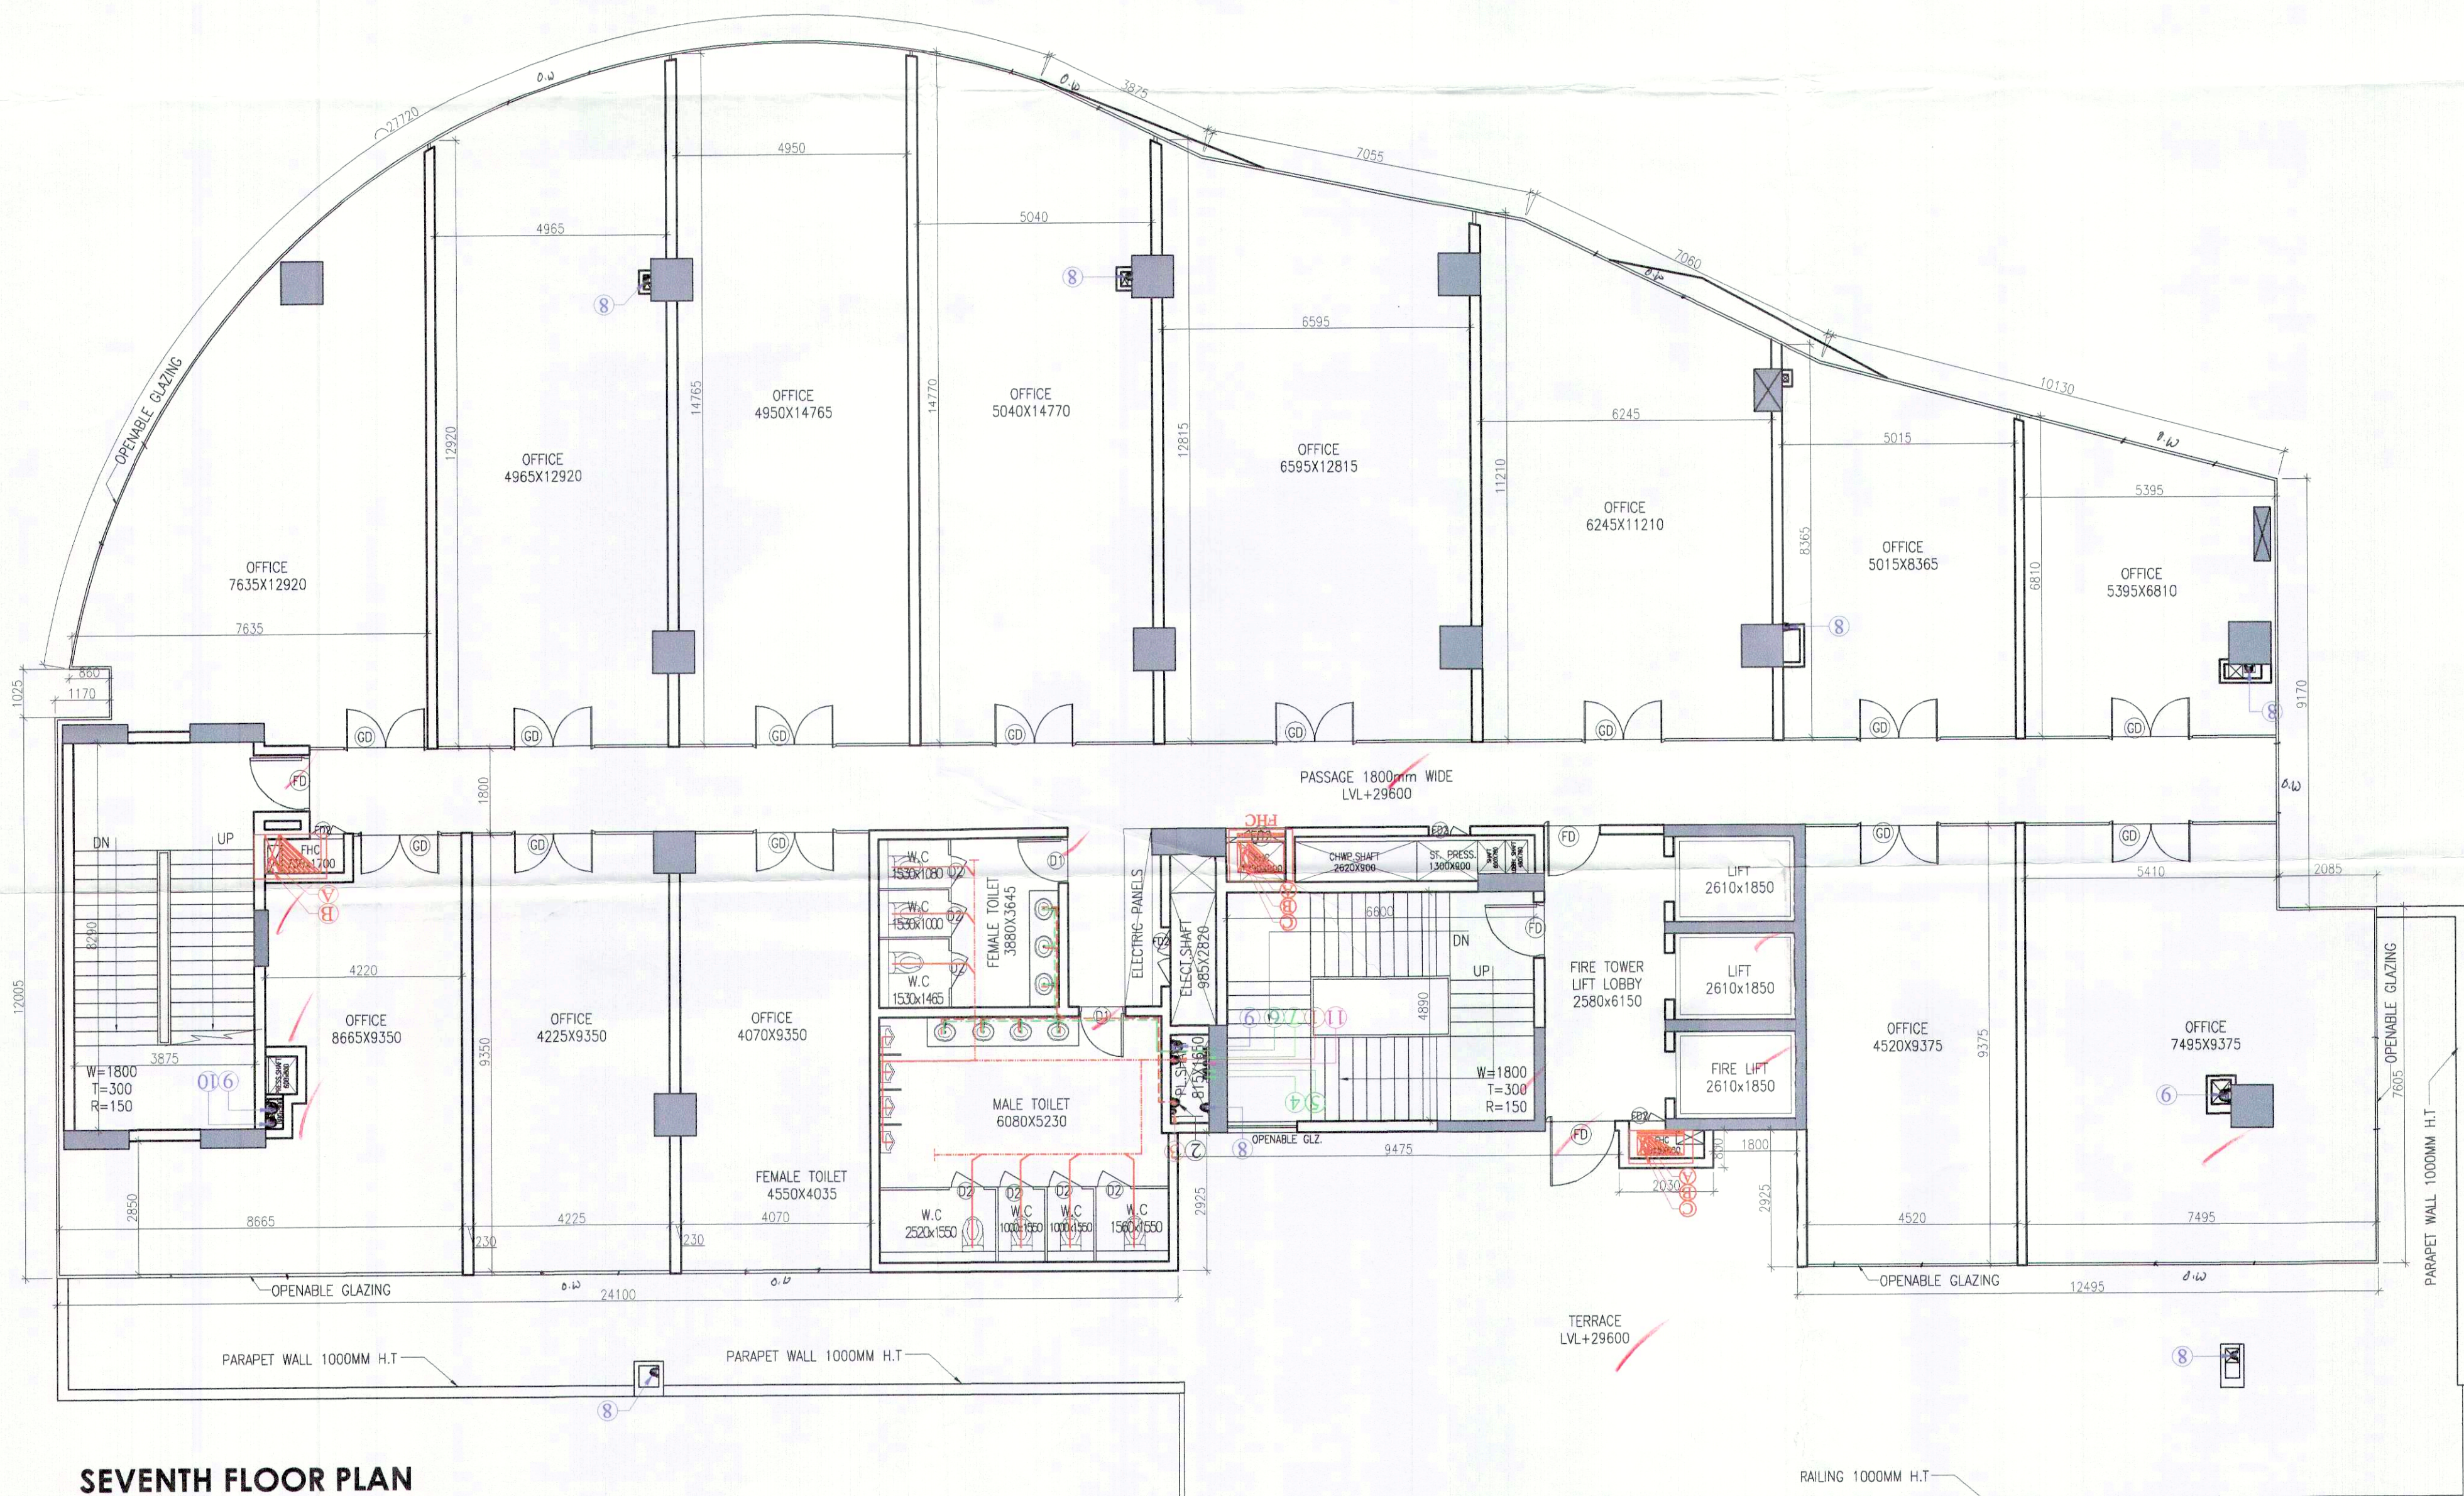

SEVENTH FLOOR PLAN

PLUMBING LEGEND:-

- 110 OD uPVC SOIL PIPE
- 110 OD uPVC WASTE PIPE
- 50 OD WASTE PIPE (FD TO FT)
- 40 OD WASTE PIPE(WASH BASIN TO FT)
- 50 OD SOIL PIPE(URINAL TO UT)
- DOMESTIC WATER SUPPLY (DWS)
- FLUSHING WATER SUPPLY (FWS)

- 110 OD uPVC SOIL PIPE
- 110 OD uPVC WASTE PIPE
- 75 OD VENT PIPE
- DWS DN. TAKE
- FWS DN. TAKE
- DWS RISER
- FWS RISER
- 110 OD uPVC RAIN WATER PIPE
- 200 OD uPVC RAIN WATER PIPE
- 160 OD uPVC RAIN WATER PIPE
- SOFT WATER SUPPLY RISER

- 110 DRAIN PIPE
- PIPE DROP
- FLOOR TRAP
- FLOOR DRAIN
- URINAL TRAP
- ACCESS DOOR
- CLEAN OUT PLUG
- FLOOR LEAN OUT
- VALVE
- 150X150 CUTOUT FOR FT,UT,WC
- FIRE HOSE CABINET
- 150# FIRE HYDRANT PIPE
- 80# DRAIN PIPE
- 150# SPRINKLER PIPE

SCHEDULE OF OPENING

S.R.	TYPE	SIZE	S.L.	LL.
1	GD	2400 X 2400	00	2400
2	GD	1200 X 2400	00	2400
3	FD	1500 X 2400	00	2400
4	FD	1200 X 2400	00	2400
5	FD	1000 X 2400	00	2400
6	D	1200 X 2400	00	2400
7	D	1050 X 2400	00	2400
8	D	750 X 2100	00	2100

PROJECT
REVISED BUILDING PLAN OF COMMERCIAL COLONY MEASURING 1.6577 ACRES (LICENCE NO. 68OF 2009 DATED 19.11.2009) IN SECTOR-37 FARIDABAD BEING DEVELOPED BY M/S MPPL LTD. (FORMERLY KNOWN AS MONNET PROJECT DEVELOPER LTD.)

ARCHITECTS
SACHDEVA CONSULTANTS.
Parnami Tower, 3rd Floor, S.C.O. 50-51, Old Judicial Complex, Civil Lines, Gurgaon - 122001
Tel.: 0124-4081801, 4081802
Email : saccon1953@gmail.com

PAKISTAN
SACHDEVA CONSULTANTS
Parnami Tower, 3rd Floor
S.C.O. 50-51, Old Judicial Complex
Civil Lines, Gurgaon - 122001 (H.K.)

ARCHITECT'S SEAL & SIGNATURE
OWNER/AUTH. SIGNATURE

Scale : 1:100
Drawing Title:- SEVENTH FLOOR PLAN
Drawing No:- RS-12