

This is a "PROVISIONAL BUILDING PLAN" approved only for the purpose of inviting objections from the general public

STR (H) Member Secretary BPAC
STAFF (H) Member BPAC
CTP (H) Chairman BPAC


DTP(HQ) ATP(HQ)

TO BE READ WITH THIS OFFICE
MEMO NO.:
DATED:


DDT MEMO BPAC
DINESH KUMAR PA(HQ)

Checked and found ok for Public Health (Internal) Service only subject to comments in forwarding letter No. SE/HQ/11337/57/22
Superintending Engineer (HQ) for Chief Engineer 1 HSPV
SDE (H)

8TH FLOOR FAR AREA CALCULATIONS					
NO.	COEFF.	BREADTH	LENGTH	NO.s	AREA (SQ.M)
ADDITION					
1	1	2.085	7.605	1	15.856
2	1	10.410	2.925	1	30.449
3	1	2.030	0.800	1	1.624
4	1	24.100	2.925	1	70.493
5	1	47.815	9.080	1	434.160
6	1	4.770+6.185/2	7.365	1	40.342
7	1	6.185+8.355/2	2.795	1	20.320
8	1	8.355+9.235/2	5.345	1	47.009
9	1	9.235+10.985/2	3.640	1	36.800
10	1	10.985+11.145/2	2.060	1	22.794
11	1	11.145+13.470/2	5.370	1	66.091
12	1	13.470+1.540/2	20.075	1	150.663
13	0.667	24.355	5.655	1	91.864
14	0.5	0.860	0.510	1	0.219
TOTAL AREA (A1)					1028.685
DEDUCTION					
D1	1	1.615	0.600	1	0.969
D2	1	2.610	1.850	3	14.466
D3	1	6.800	4.890	1	32.274
D4	1	5.000	0.900	1	4.500
D5	1	1.250	0.900	1	1.125
D6	1	0.985	0.800	1	0.591
D7	1	0.985	2.820	1	2.778
D8	1	0.815	1.750	1	1.426
D9	1	0.300	0.500	1	0.150
D10	1	0.600	0.800	1	0.480
D11	1	3.875	8.290	1	32.124
D12	1	1.700	0.730	1	1.241
TOTAL AREA (D)					92.143
NET FAR AREA (A-D)					936.542

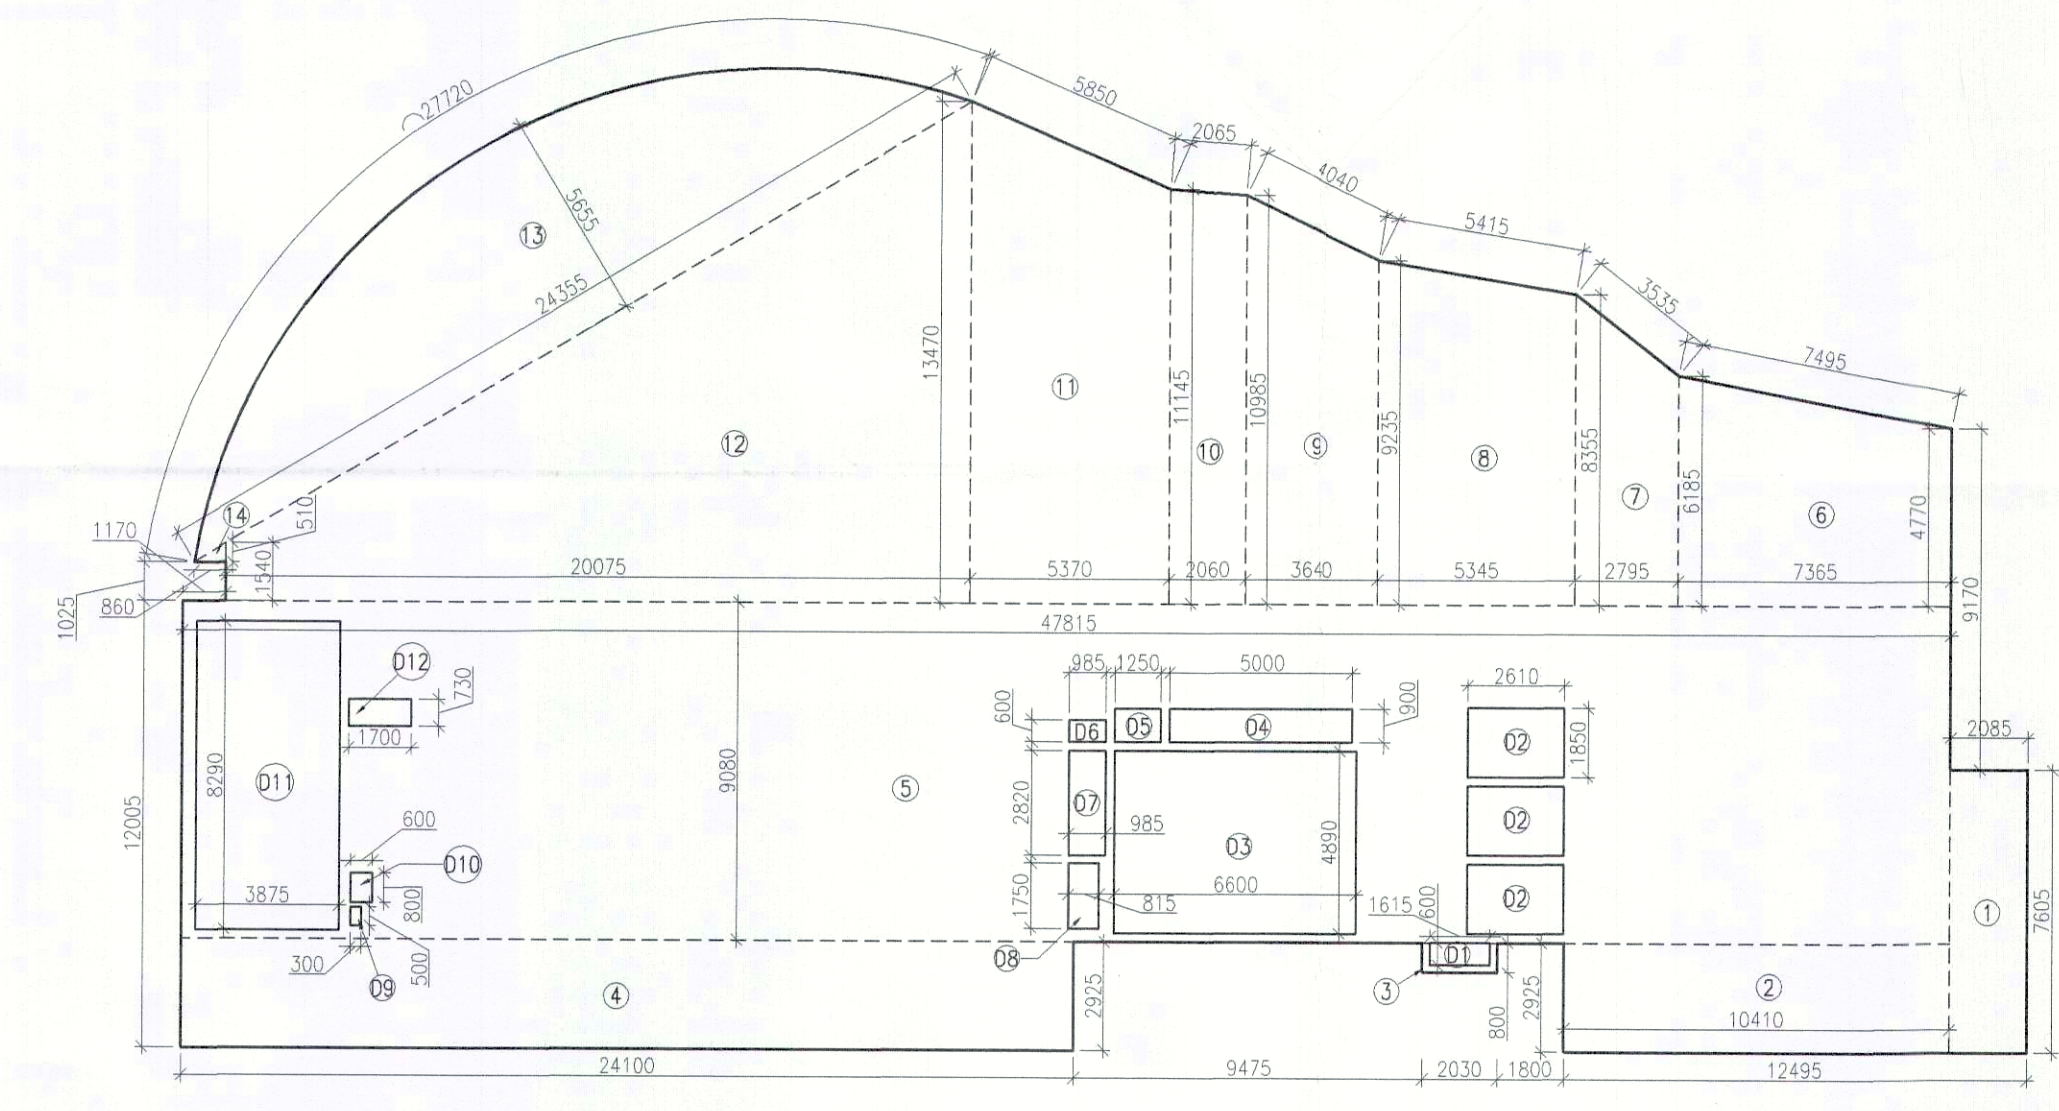

8TH FLOOR AREA DIAGRAM

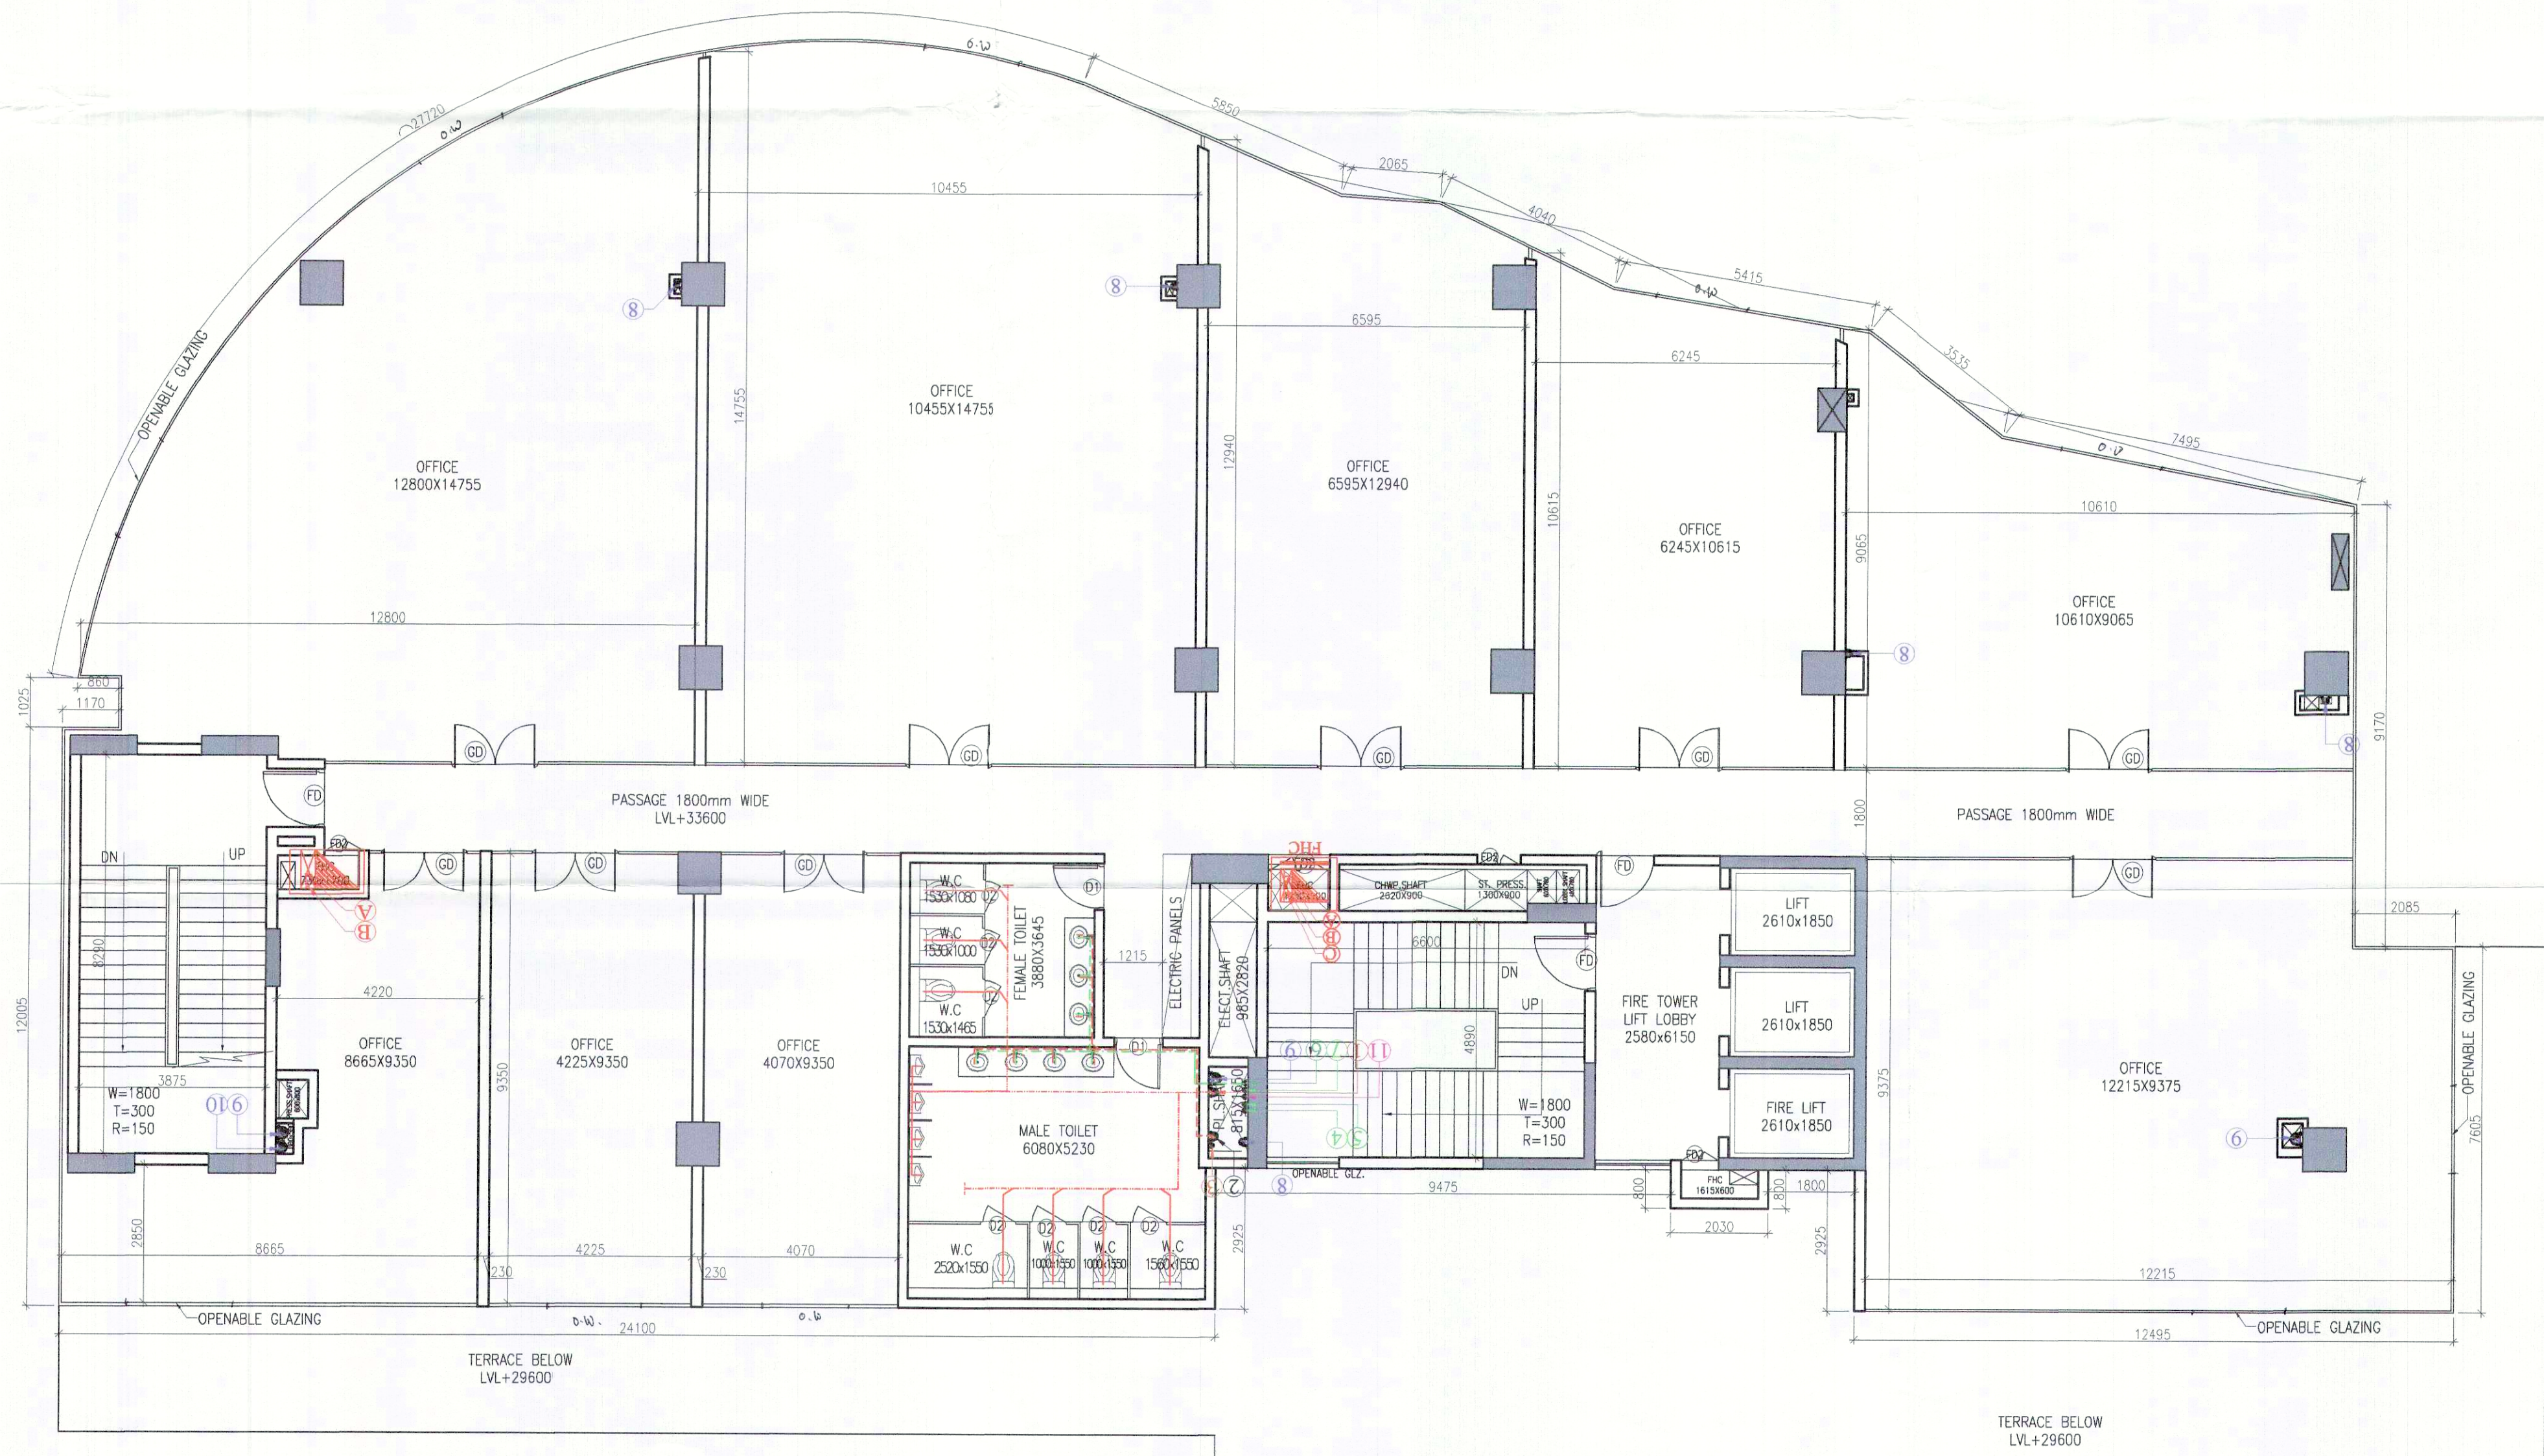

EIGHTH FLOOR PLAN

TOILET CALCULATION				
F.A.R. AREA ON 8TH FLOOR = 936.542 SQM.				
DENSITY ON 8TH FLOOR = 94 Nos.				
NO.	REQUIRED		PROVIDED	
	MALE (2/3)	FEMALE(1/3)	MALE (2/3)	FEMALE(1/3)
W.C.	3	1	4	3
URINAL	3	-	4	-
WASH BASIN	3	1	3	3

PLUMBING LEGEND:-

- 110 OD uPVC SOIL PIPE
- 110 OD uPVC WASTE PIPE
- 75 OD VENT PIPE
- DWS DN. TAKE
- FWS DN. TAKE
- DWS RISER
- FWS RISER
- 110 OD uPVC RAIN WATER PIPE
- 200 OD uPVC RAIN WATER PIPE
- 160 OD uPVC RAIN WATER PIPE
- SOFT WATER SUPPLY RISER
- 110 DRAIN PIPE
- PIPE DROP
- FLOOR TRAP
- FLOOR DRAIN
- URINAL TRAP
- ACCESS DOOR
- CLEAN OUT PLUG
- FLOOR LEAN OUT
- VALVE
- 150X150 CUTOUT FOR FT,UT,WC
- FIRE HOSE CABINET
- 150# FIRE HYDRANT PIPE
- 80# DRAIN PIPE
- 150# SPRINKLER PIPE

SCHEDULE OF OPENING				
S.R	TYPE	SIZE	S.L.	L.L.
1	GD	2400 X 2400	00	2400
2	GD1	1200 X 2400	00	2400
3	FD	1500 X 2400	00	2400
4	FD1	1200 X 2400	00	2400
5	FD2	1000 X 2400	00	2400
6	D	1200 X 2400	00	2400
7	D1	1050 X 2400	00	2400
8	D2	750 X 2100	00	2100

PROJECT
REVISED BUILDING PLAN OF COMMERCIAL COLONY MEASURING 1.6577 ACRES (LICENCE NO. 68OF 2009 DATED 19.11.2009) IN SECTOR-37 FARIDABAD BEING DEVELOPED BY M/S MPDL LTD. (FORMERLY KNOWN AS MONNET PROJECT DEVELOPER LTD.)

ARCHITECTS
SACHDEVA CONSULTANTS.
Pannami Tower, 3rd Floor, S.C.O. 50-51, Old Judicial Complex, Civil Lines, Gurgaon - 122001
Tel.: 0124-4081801, 4081802
Email : saccon1953@gmail.com

OWNER/AUTH.
SIGNATURE

Scale : 1:100
Drawing Title:- EIGHTH FLOOR PLAN
RS-13