

This is a "PROVISIONAL BUILDING PLAN" approved only for the purpose of inviting objections from the general public


STP(HQ) Member Secretary BPAC
STP(F) Member BPAC
CTPH(HQ) Chairperson BPAC
DTP(HQ)
DTP(F) Member BPAC
JINESH KUMAR PA(HQ)

13TH FLOOR AREA DIAGRAM

TOILET CALCULATION				
F.A.R. AREA ON 13TH FLOOR = 496.194 SQM.				
DENSITY ON 13TH FLOOR = 50 Nos.				
NO.	REQUIRED		PROVIDED	
	MALE (2/3)	FEMALE(1/3)	MALE (2/3)	FEMALE(1/3)
W.C.	33	17	33	17
URINAL	1	-	2	-
WASH BASIN	1	1	3	2

TOILET CALCULATION				
F.A.R. AREA ON 14TH FLOOR = 331.375 SQM.				
DENSITY ON 14TH FLOOR = 33 Nos.				
NO.	REQUIRED		PROVIDED	
	MALE (2/3)	FEMALE(1/3)	MALE (2/3)	FEMALE(1/3)
W.C.	22	11	22	11
URINAL	1	-	2	-
WASH BASIN	1	1	3	2

FOURTEEN FLOOR PLAN

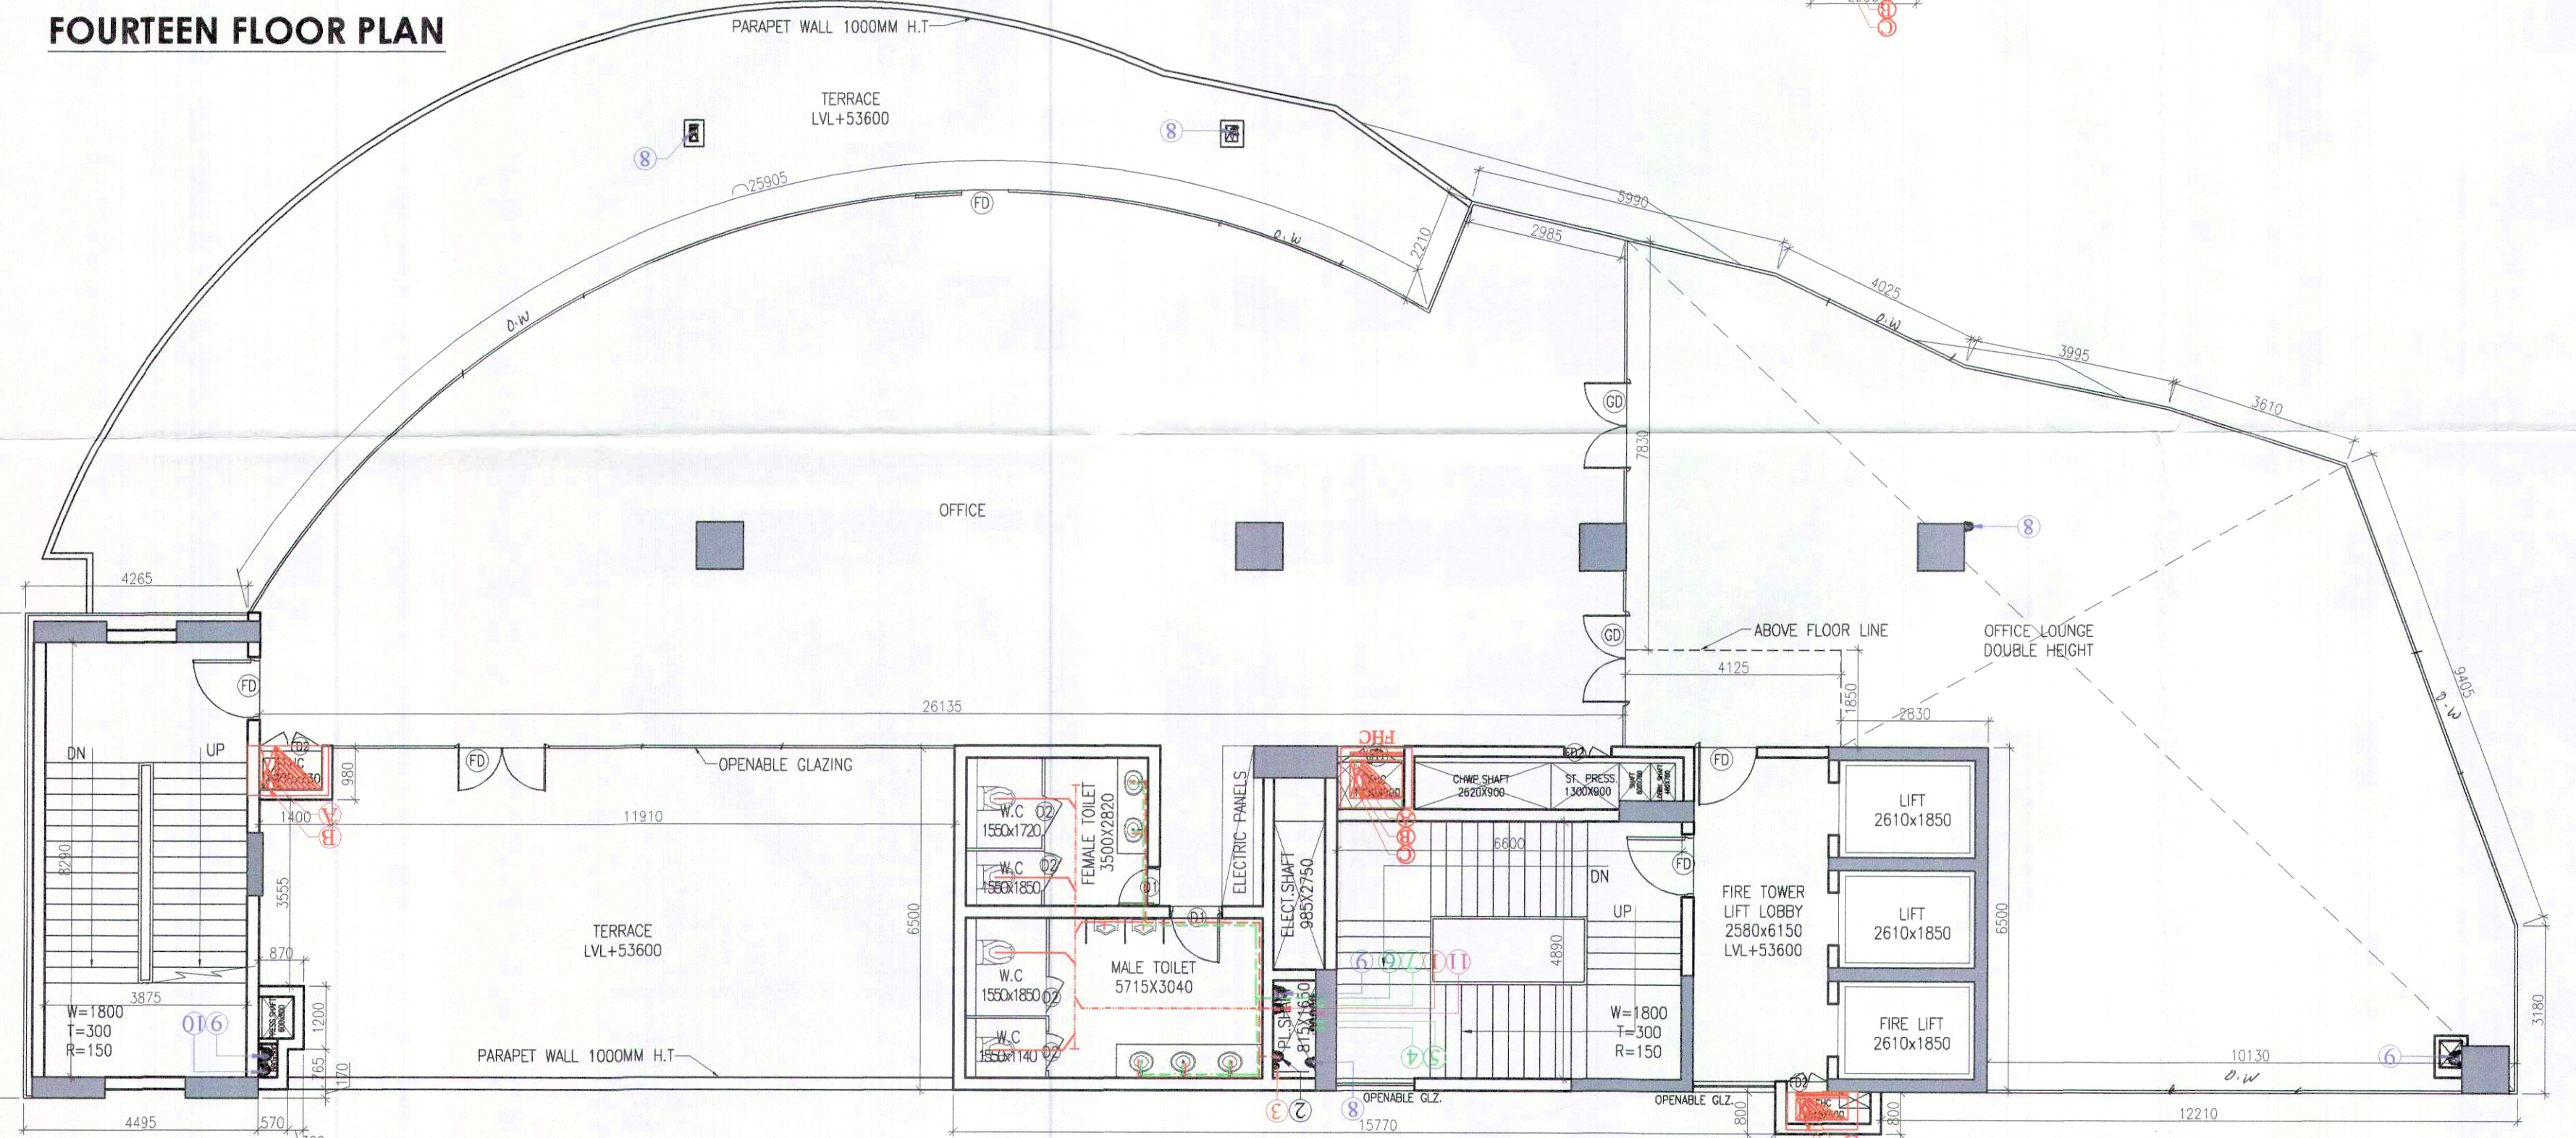

THIRTEEN FLOOR PLAN

13TH FLOOR FAR AREA CALCULATIONS				
NO.	COEFF.	BREADTH	LENGTH	NO. s/AREA (SQ.M)
ADDITION				
F1	3.180	11.980	2	3.310
F2	11.980	13.090	2	3.435
F3	13.090	13.880	2	3.915
F4	13.880	15.620	2	3.630
F5	1	2.030	0.800	1.624
F6	15.620	14.925	2	6.665
F7	0.5	2.210	5.990	1.619
F8	1	9.055	6.500	58.858
F9	8.425	2.580	2	22.595
F10	0.667	23.340	4.915	76.516
F11	1	1.400	0.980	1.372
F12	1	4.265	8.315	35.463
F13	1	0.230	5.735	1.319
F14	1	0.870	1.200	1.044
F15	1	5.065	0.765	3.875
F16	1	4.495	0.170	0.764
TOTAL AREA (A1)				588.057
DEDUCTION				
D1	1	1.615	0.600	0.969
D2	1	2.610	1.850	14.486
D3	1	6.600	4.890	32.274
D4	1	5.000	0.900	4.500
D5	1	1.250	0.900	1.125
D6	1	0.985	0.600	0.591
D7	1	0.985	2.820	2.778
D8	1	0.815	1.750	1.426
D9	1	1.200	0.730	0.876
D10	1	3.875	8.290	32.124
D11	1	0.600	0.800	0.480
D12	1	0.370	0.635	0.235
TOTAL AREA (D)				91.863
NET FAR AREA (A-D)				496.194

PLUMBING LEGEND:-

- 110 OD uPVC SOIL PIPE
- 110 OD uPVC WASTE PIPE
- 50 OD WASTE PIPE (FD TO FT)
- 40 OD WASTE PIPE(WASH BASIN TO FT)
- 50 OD SOIL PIPE(URINAL TO UT)
- DOMESTIC WATER SUPPLY (DWS)
- FLUSHING WATER SUPPLY (FWS)

- 110 OD uPVC SOIL PIPE
- 110 OD uPVC WASTE PIPE
- 75 OD VENT PIPE
- DWS DN. TAKE
- FWS DN. TAKE
- DWS RISER
- FWS RISER
- 110 OD uPVC RAIN WATER PIPE
- 200 OD uPVC RAIN WATER PIPE
- 160 OD uPVC RAIN WATER PIPE
- SOFT WATER SUPPLY RISER

- 110 DRAIN PIPE
- PIPE DROP
- FLOOR TRAP
- FLOOR DRAIN
- URINAL TRAP
- CLEAN OUT PLUG
- FLOOR LEAN OUT
- VALVE
- 150X150 CUTOFF FOR FT,UT,WC
- FIRE HOSE CABINET
- 150# FIRE HYDRANT PIPE
- 80# DRAIN PIPE
- 150# SPRINKLER PIPE

TO BE READ WITH THIS OFFICE MEMO NO.: DATED :

Checked and found ok for Public Health (Internal) Service only subject to comments in forwarding letter No. SE(HQ)/11337/2019/5742
Superintending Engineer (HQ) for Chief Engineer 1 HSVP
SDE (W)

SCHEDULE OF OPENING				
S.R	TYPE	SIZE	S.L	L.L
1	GD	2400 X	2400	00
2	GD1	1200 X	2400	00
3	FD	1500 X	2400	00
4	FD1	1200 X	2400	00
5	FD2	1000 X	2400	00
6	D	1200 X	2400	00
7	D1	1050 X	2400	00
8	D2	750 X	2100	00

PROJECT
REVISED BUILDING PLAN OF COMMERCIAL COLONY MEASURING 1.6577 ACRES (LICENCE NO. 68OF 2009 DATED 19.11.2009) IN SECTOR-37 FARIDABAD BEING DEVELOPED BY M/S MPDL LTD. (FORMERLY KNOWN AS MONNET PROJECT DEVELOPER LTD.)

ARCHITECTS

SACHDEVA CONSULTANTS.
Parnami Tower, 3rd Floor, S.C.O. 50-51, Old Judicial Complex, Civil Lines, Gurgaon - 122001
Tel.: 0124-4081801, 4081802
Email : saccon1953@gmail.com

ARCHITECT'S SEAL & SIGNATURE

OWNER/AUTH. SIGNATURE

Scale :

1:100

Drawing Title:-

13TH & 14TH FLOOR PLAN

RS-16