


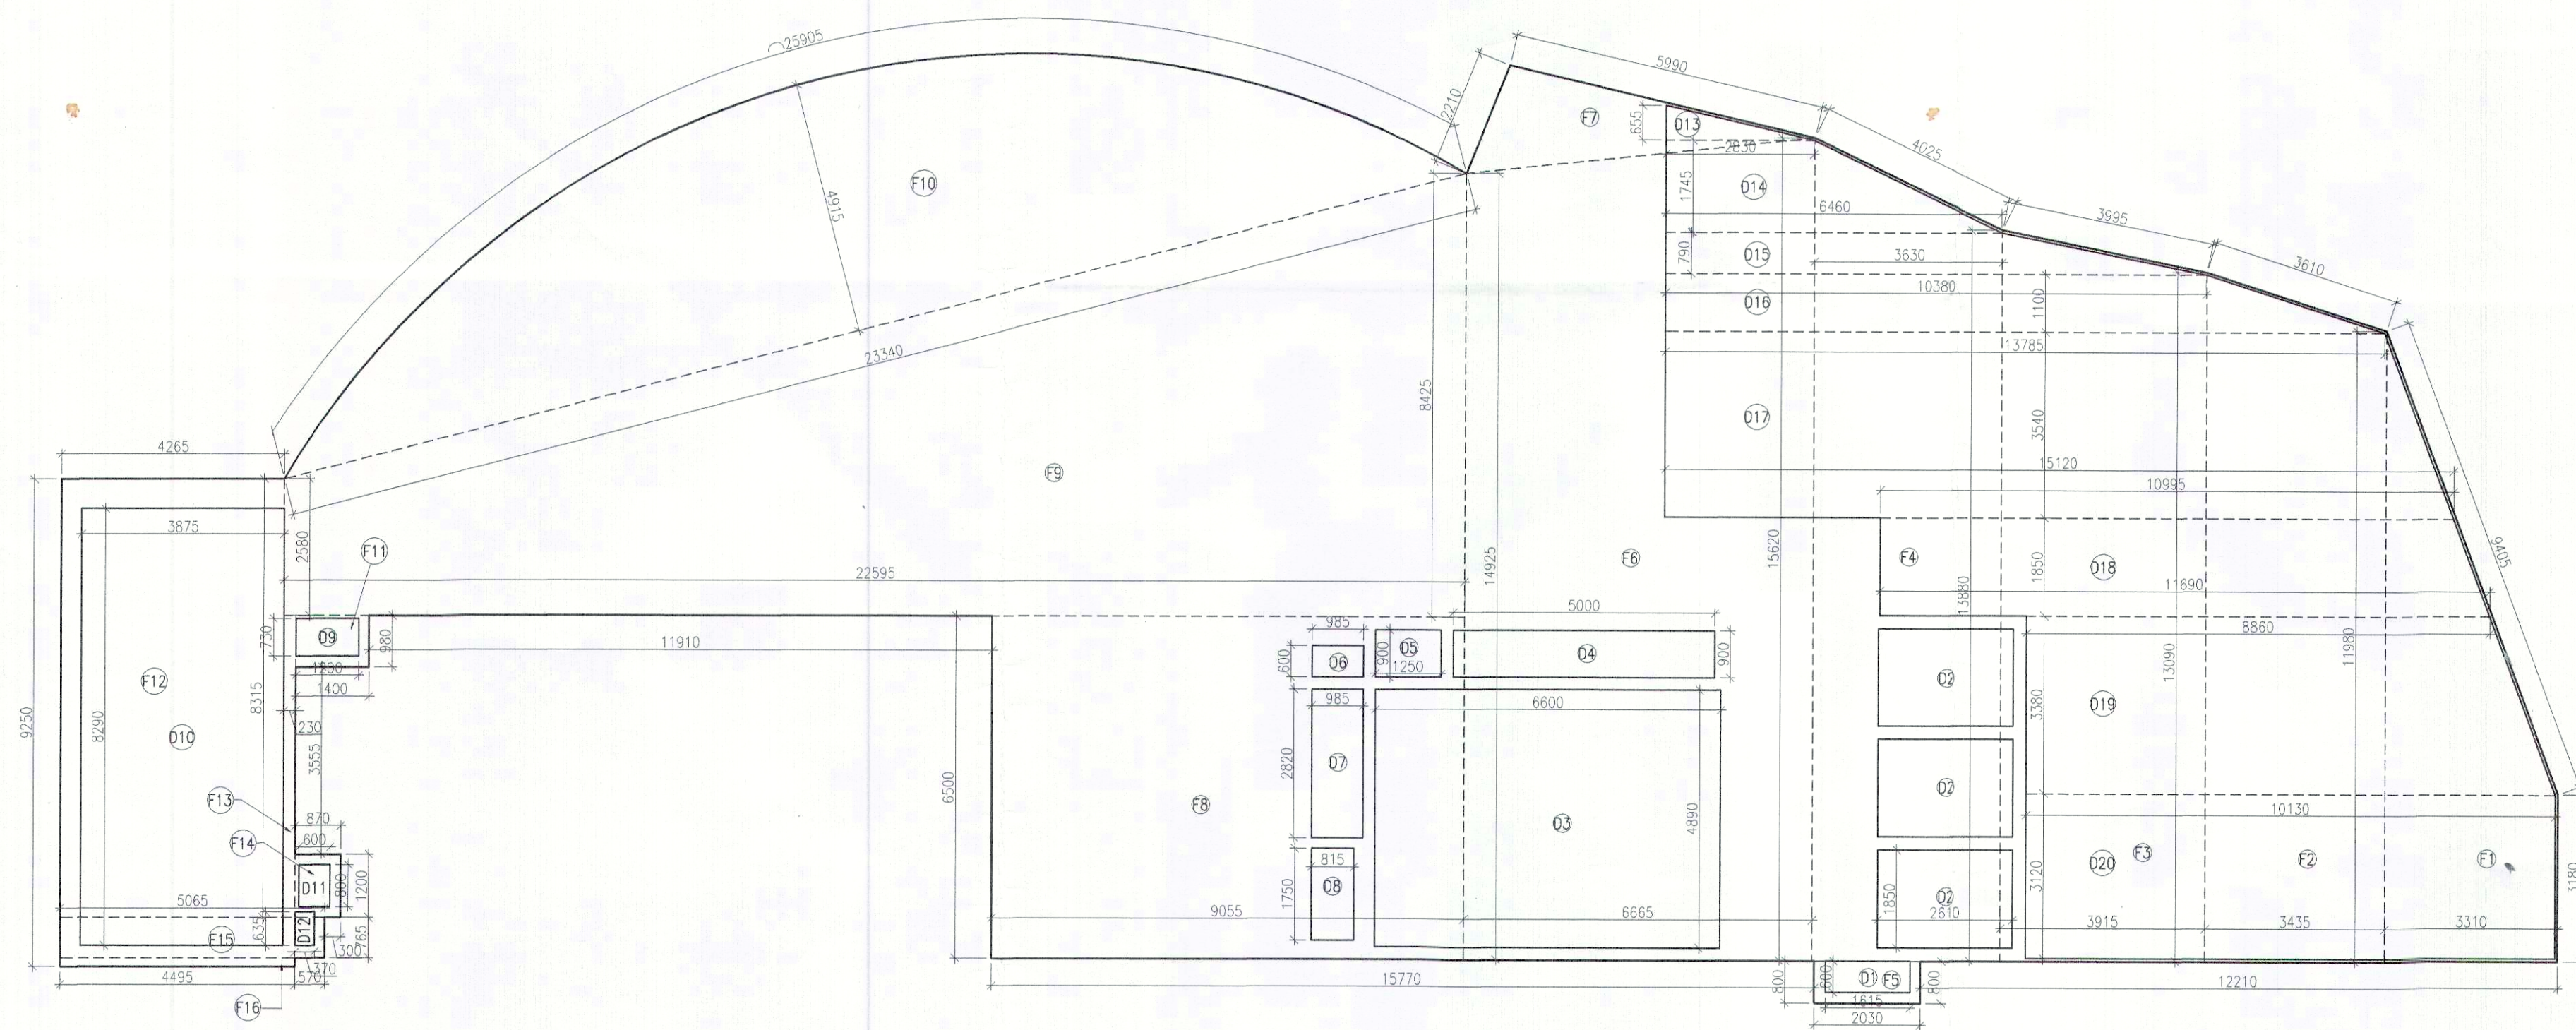

14TH FLOOR AREA DIAGRAM

14TH FLOOR FAR AREA CALCULATIONS				
NO.	COEFF.	BREADTH	LENGTH	NO.s AREA (SQ.M)
ADDITION				
F1	3.180+11.980/2	3.310	1	25.090
F2	11.980+13.090/2	3.435	1	43.058
F3	13.090+13.880/2	3.915	1	52.794
F4	13.880+15.620/2	3.630	1	53.543
F5	1	2.030	0.800	1.624
F6	15.620+14.925/2	6.665	1	101.791
F7	0.5	2.210	5.990	6.619
F8	1	9.055	6.500	58.858
F9	8.425+2.580/2	22.595	1	124.329
F10	0.667	23.340	4.915	76.516
F11	1	1.400	0.980	1.372
F12	1	4.265	8.315	35.463
F13	1	0.230	5.735	1.319
F14	1	0.870	1.200	1.044
F15	1	5.065	0.765	3.875
F16	1	4.495	0.170	0.764
TOTAL AREA (A1)				588.057
DEDUCTION				
D1	1	1.615	0.600	0.969
D2	1	2.610	1.850	14.486
D3	1	6.600	4.890	32.274
D4	1	5.000	0.900	4.500
D5	1	1.250	0.900	1.125
D6	1	0.985	0.600	0.591
D7	1	0.985	2.820	2.778
D8	1	0.815	1.750	1.426
D9	1	1.200	0.730	0.876
D10	1	3.875	8.290	32.124
D11	1	0.600	0.800	0.480
D12	1	0.370	0.635	0.235
D13	0.5	2.830	0.655	0.927
D14	6.460+2.830/2	1.745	1	8.106
D15	6.460+10.380/2	0.790	1	6.652
D16	10.380+13.785/2	1.100	1	13.291
D17	15.120+13.785/2	3.540	1	51.162
D18	10.995+11.690/2	1.850	1	20.984
D19	8.860+10.130/2	3.380	1	32.093
D20	1	10.130	3.120	31.606
TOTAL AREA (D)				256.682
NET FAR AREA (A-D)				331.375

This is a "PROVISIONAL BUILDING PLAN" approved only for the purpose of inviting objections from the general public


DDP (T) MEMBER BPAC
SVP (T) MEMBER BPAC
CTM (T) Chairman BPAC

DTP(HQ)
ATP(HQ)
DDP (T) MEMBER BPAC
DINESH KUMAR PA(HQ)

Checked and found ok for Public Health (Internal) Service only subject to comments in forwarding letter No. SE(HQ) 11/3/22
Superintending Engineer (HQ) for Chief Engineer 1 HSVP
SDE(W)


TO BE READ WITH THIS OFFICE MEMO NO.: DATED :

PLUMBING LEGEND:-	
110 OD UPVC SOIL PIPE	110 OD UPVC WASTE PIPE
50 OD WASTE PIPE (FD TO FT)	40 OD WASTE PIPE (WASH BASIN TO FT)
50 OD SOIL PIPE (URINAL TO UT)	DOMESTIC WATER SUPPLY (DWS)
FLUSHING WATER SUPPLY (FWS)	
110 OD UPVC SOIL PIPE	110 OD UPVC WASTE PIPE
75 OD VENT PIPE	DWS DN. TAKE
FWS DN. TAKE	DWS RISER
FWS RISER	110 OD UPVC RAIN WATER PIPE
200 OD UPVC RAIN WATER PIPE	160 OD UPVC RAIN WATER PIPE
SOFT WATER SUPPLY RISER	110 DRAIN PIPE
C = PIPE DROP	FT = FLOOR TRAP
FD = FLOOR DRAIN	UT = URINAL TRAP
AD = ACCESS DOOR	COP = CLEAN OUT PLUG
FCO = FLOOR LEAN OUT	V = VALVE
150X150 CUTOUT FOR FT, UT, WC	FHC = FIRE HOSE CABINET
150# FIRE HYDRANT PIPE	80# DRAIN PIPE
150# SPRINKLER PIPE	

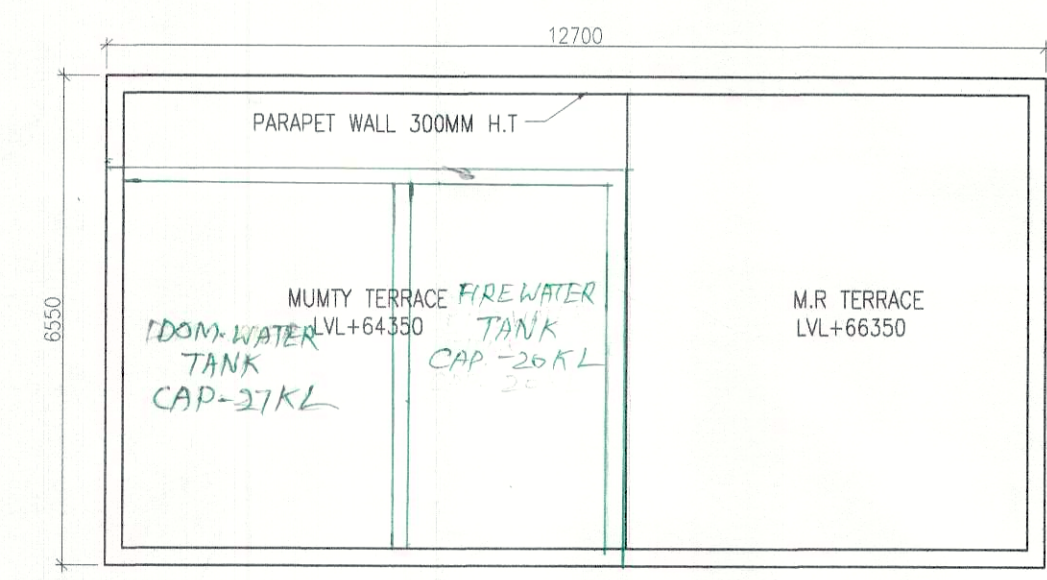


MUMTY & M.R. TERRACE PLAN

MUMTY MACHINE ROOM AREA CALCULATIONS				
NO.	COEFF.	BREADTH	LENGTH	NO.s AREA (SQ.M)
1	1	12.700	6.550	83.185
2	1	4.335	8.750	37.931
STARCASE AREA				419.562
STARCASE AREA				417.609
TOTAL AREA (A)				958.287

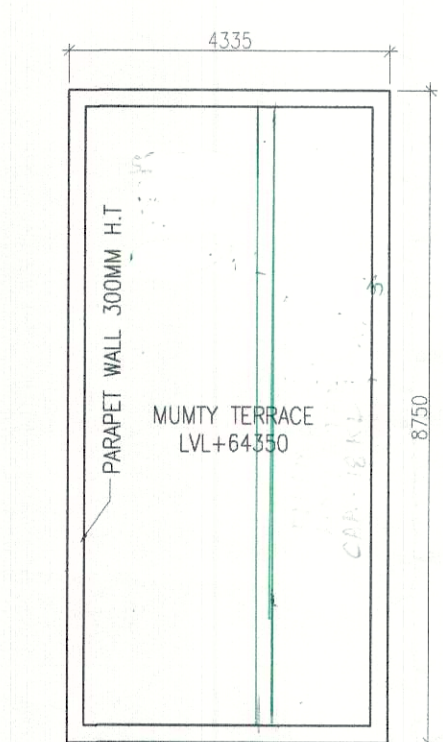

MUMTY TERRACE PLAN

SCHEDULE OF OPENING				
S.R	TYPE	SIZE	S.L	LL
1	GD	2400 X 2400	00	2400
2	GD	1200 X 2400	00	2400
3	FD	1500 X 2400	00	2400
4	FD	1200 X 2400	00	2400
5	FD	1000 X 2400	00	2400
6	D	1200 X 2400	00	2400
7	D	1050 X 2400	00	2400
8	D	750 X 2100	00	2100

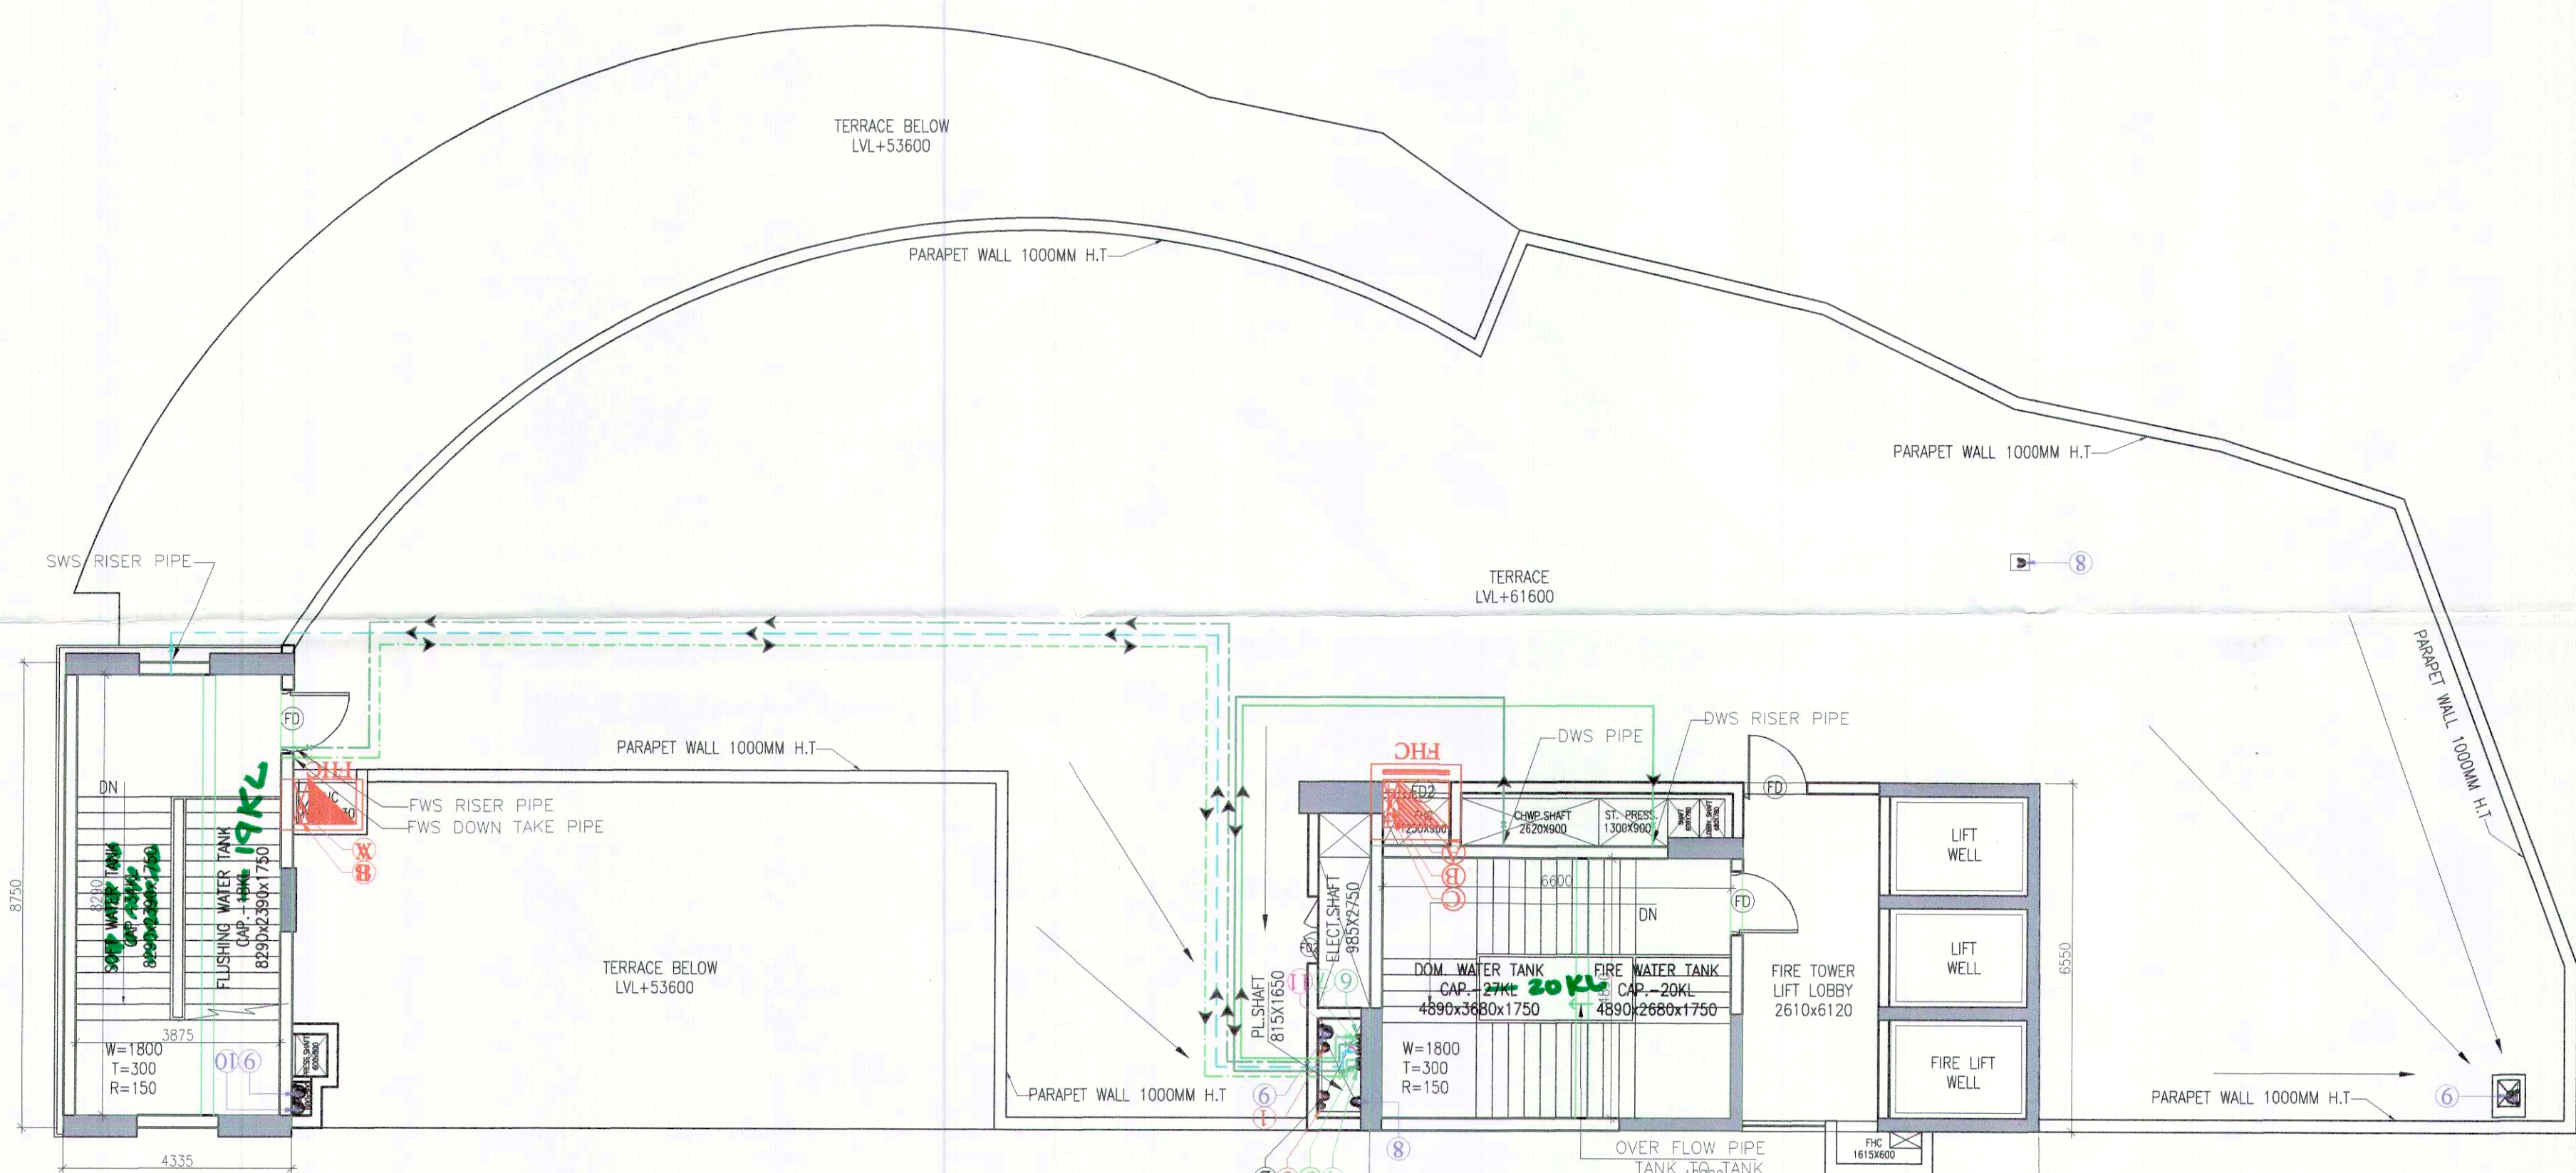

TERRACE PLAN

PROJECT
REVISED BUILDING PLAN OF COMMERCIAL COLONY MEASURING 1.6577 ACRES (LICENCE NO. 68OF 2009 DATED 19.11.2009) IN SECTOR-37 FARIDABAD BEING DEVELOPED BY M/S MPDL LTD. FORMERLY KNOWN AS MONNET PROJECT
SACHDEVA CONSULTANTS.
Pannami Tower, 3rd Floor, S.C.O. 50-51, Old Judicial Complex, Civil Lines, Gurgaon - 122001
Tel.: 0124-4081801, 4081802
Email : saccon1953@gmail.com

ARCHITECT'S SEAL & SIGNATURE
OWNER/AUTH. SIGNATURE
Scale : 1:100
Drawing Title:-
Drawing No:-