

This is a "PROVISIONAL BUILDING PLAN" approved only for the purpose of inviting objections from the general public

Member Secretary BPAC
Member BPAC
Chairman BPAC
DTP(HQ)
ATP(HQ)


Checked and found ok for Public Health (Internal) Service only subject to comments in forwarding letter No. SE/HOI/...

Superintending Engineer (HQ) for Chief Engineer 1 HSVP


DINESH KUMAR PA(HQ)

TO BE READ WITH THIS OFFICE MEMO NO. DATED :

FIRST FLOOR FAR AREA CALCULATIONS				
NO.	COEFF.	BREADTH	LENGTH	NO.s / AREA (SQ.M)
ADDITION				
1	1	4.000	10.220	1 40.880
2	1	52.405	26.520	1 1389.781
3	1	3.700+6.125/2	13.205	1 64.870
4	1	22.515	6.125	1 137.904
5	1	2.975	3.625	1 10.784
6	1	3.050	8.170	1 24.919
7	1	2.250+3.395/2	6.025	1 17.006
TOTAL AREA (A1)				1686.143
DEDUCTION				
D1	1	9.670	20.180	1 195.141
D2	1	2.610	1.850	3 14.486
D3	1	6.600	4.890	1 32.274
D4	1	5.000	0.900	1 4.500
D5	1	1.250	0.900	1 1.125
D6	1	0.985	0.800	1 0.591
D7	1	0.985	2.820	1 2.778
D8	1	0.815	1.750	1 1.426
D9	1	0.300	0.500	1 0.150
D10	1	0.600	0.800	1 0.480
D11	1	3.875	8.290	1 32.124
D12	1	1.200	0.730	1 0.876
D13	1	2.770	2.325	1 6.440
TOTAL AREA (D)				292.390
NET FAR AREA (A-D)				1393.753

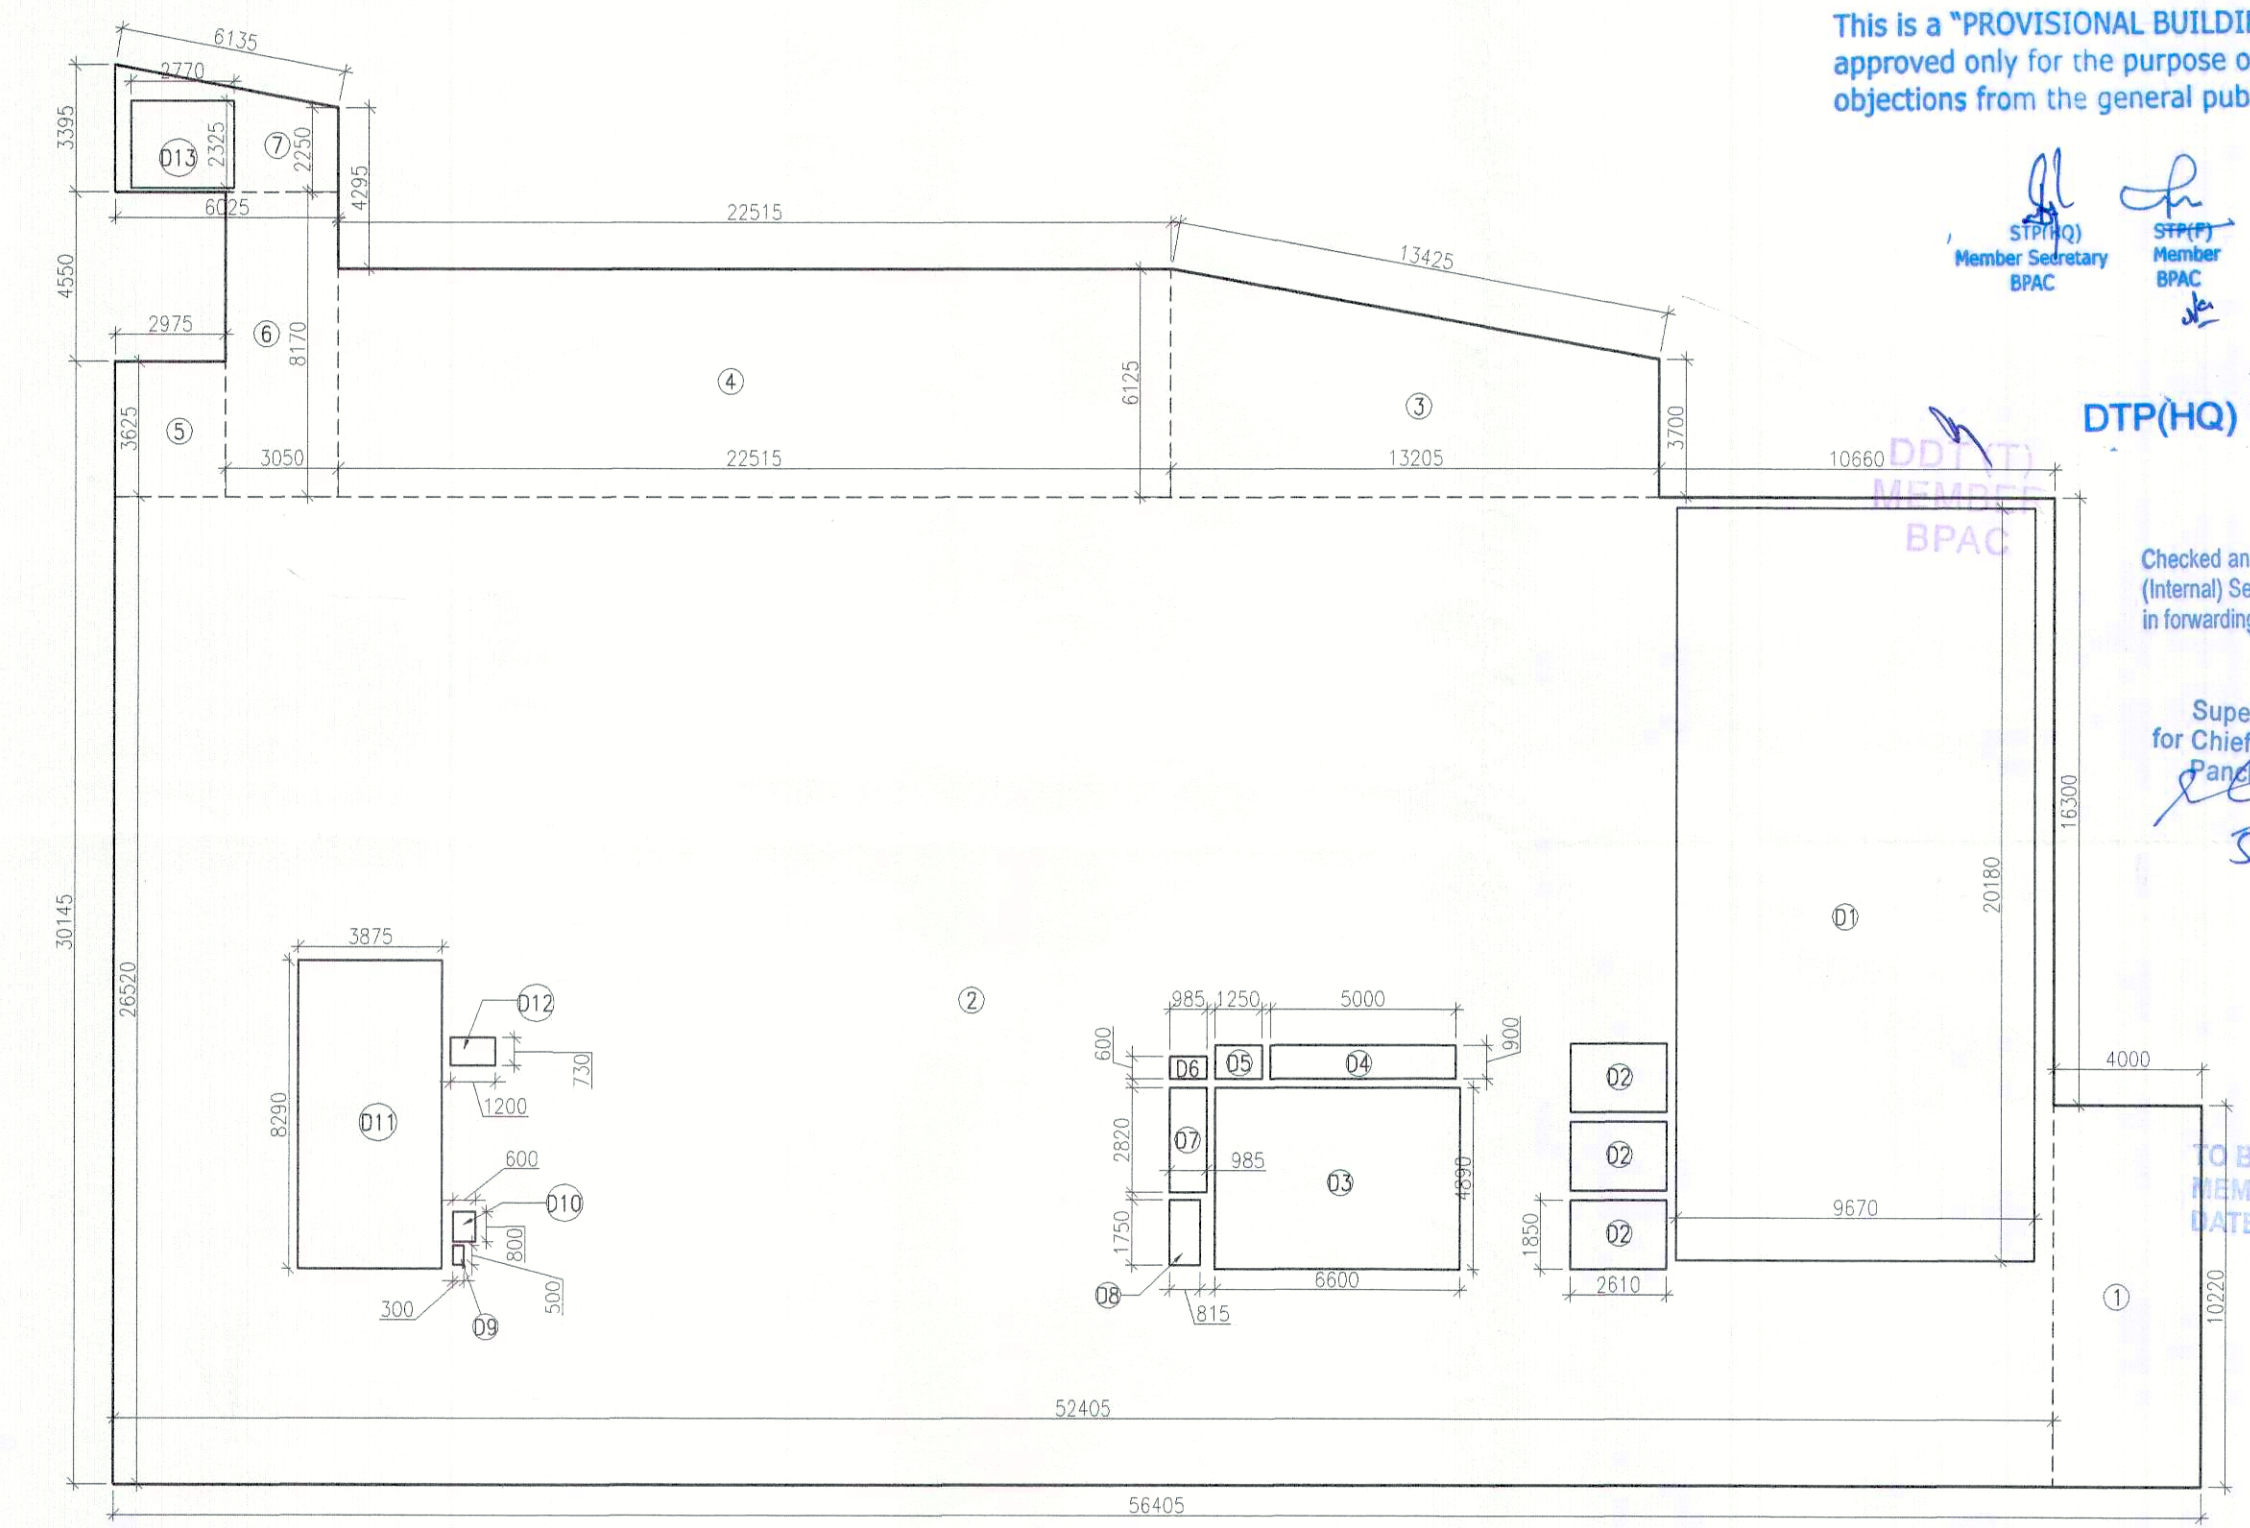

FIRST FLOOR AREA DIAGRAM

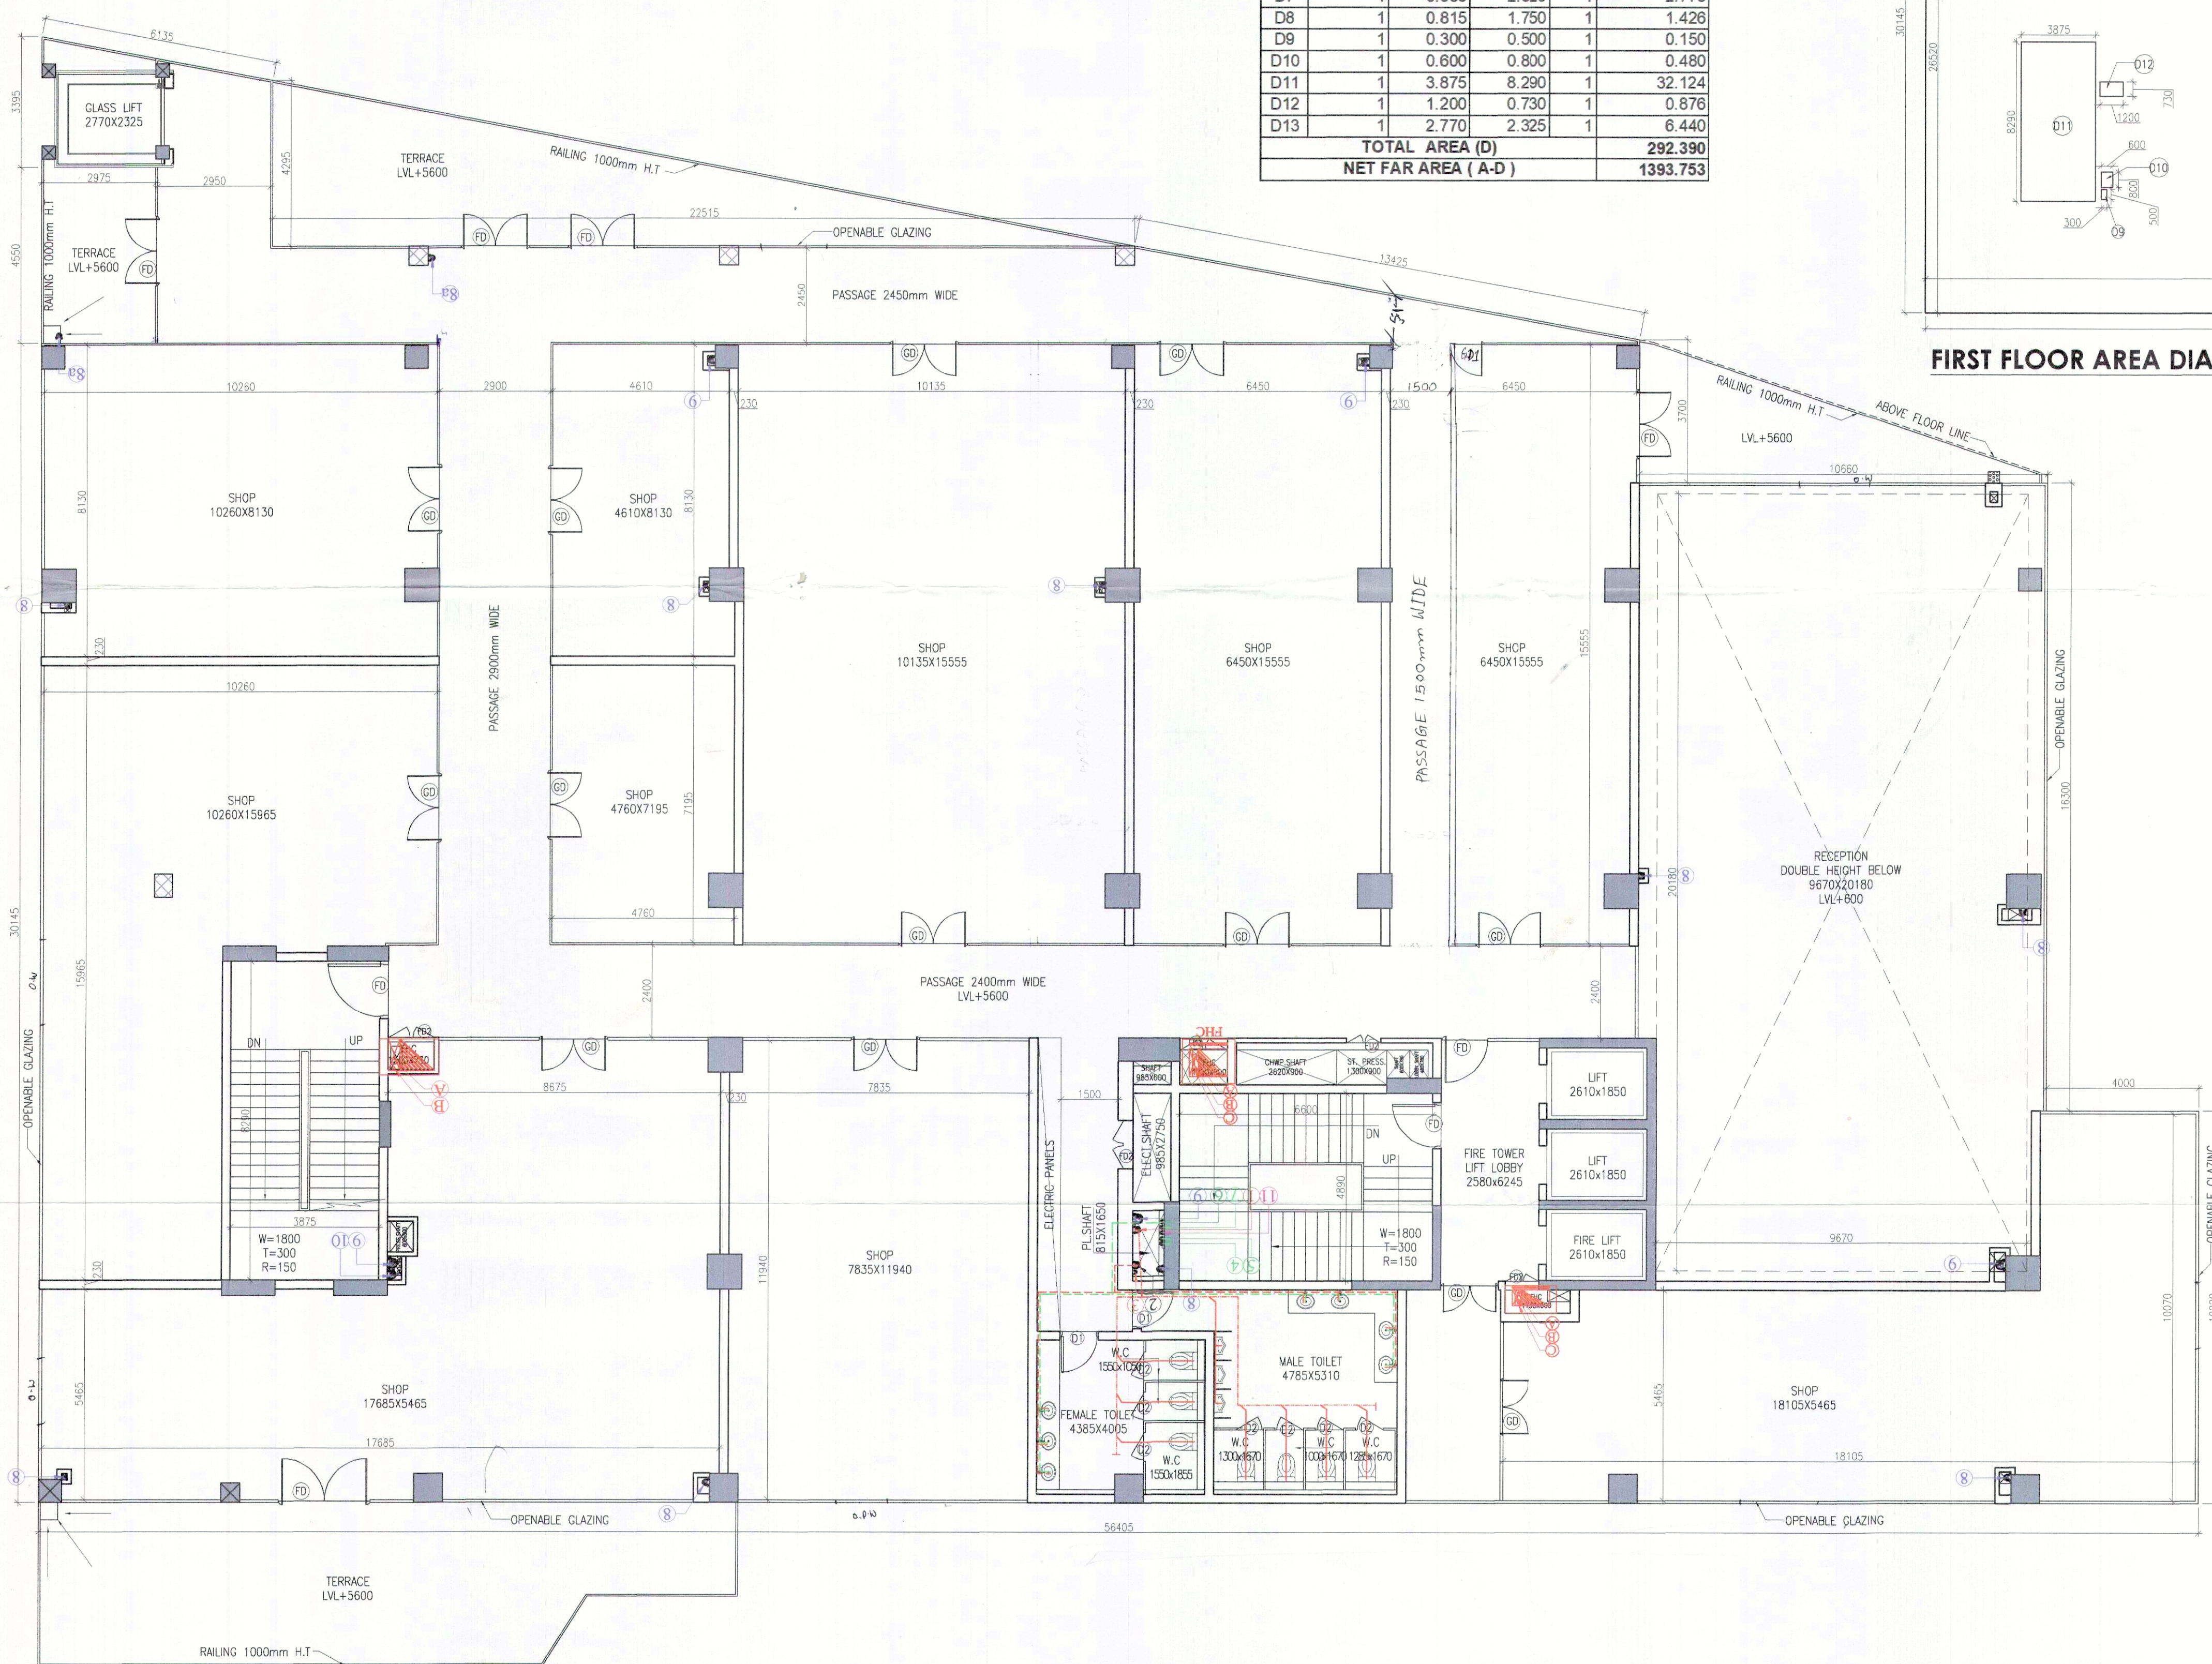

FIRST FLOOR PLAN

TOILET CALCULATION				
F.A.R. AREA ON FIRST FLOOR = 1393.753 SQM.				
DENSITY ON FIRST FLOOR = 139 Nos.				
REQUIRED		PROVIDED		
NO.	MALE (2/3)	FEMALE(1/3)	MALE (2/3)	FEMALE(1/3)
W.C.	3	2	4	3
URINAL	3	-	3	-
WASH BASIN	3	2	4	3

PLUMBING LEGEND:-				
110 OD uPVC SOIL PIPE	110 OD uPVC WASTE PIPE	50 OD WASTE PIPE (FD TO FT)	40 OD WASTE PIPE(WASH BASIN TO FT)	50 OD SOIL PIPE(URINAL TO UT)
DOMESTIC WATER SUPPLY (DWS)	FLUSHING WATER SUPPLY (FWS)			
110 OD uPVC SOIL PIPE	110 OD uPVC WASTE PIPE	75 OD VENT PIPE	DWS DN. TAKE	DWS RISER
FWS RISER	110 OD uPVC RAIN WATER PIPE	200 OD uPVC RAIN WATER PIPE	160 OD uPVC RAIN WATER PIPE	SOFT WATER SUPPLY RISER
110 DRAIN PIPE	PIPE DROP	FLOOR TRAP	FLOOR DRAIN	URINAL TRAP
ACCESS DOOR	CLEAN OUT PLUG	FLOOR LEAN OUT	VALVE	150X150 CUTOUT FOR FT,UT,W.C
FIRE HOSE CABINET	150# FIRE HYDRANT PIPE	80# DRAIN PIPE	150# SPRINKLER PIPE	

SCHEDULE OF OPENING				
S.R	TYPE	SIZE	S.L.	LL.
1	GD	2400 X 2400	00	2400
2	GD1	1200 X 2400	00	2400
3	FD	1500 X 2400	00	2400
4	FD1	1200 X 2400	00	2400
5	FD2	1000 X 2400	00	2400
6	D	1200 X 2400	00	2400
7	D1	1050 X 2400	00	2400
8	D2	750 X 2100	00	2100

PROJECT
REVISED BUILDING PLAN OF COMMERCIAL COLONY MEASURING 1.6577 ACRES (LICENCE NO. 480F 2009 DATED 19.11.2009) IN SECTOR-37 FARIDABAD BEING DEVELOPED BY M/S MPDL LTD. (FORMERLY KNOWN AS MONNET PROJECT DEVELOPER LTD.)

ARCHITECTS
SACHDEVA CONSULTANTS.
Parnami Tower, 3rd Floor, S.C.O. 50-51, Old Judicial Complex, Civil Lines, Gurgaon - 122001
Tel.: 0124-4081801, 4081802
Email : saccon1953@gmail.com

ARCHITECT'S SEAL & SIGNATURE
OWNER/AUTH. SIGNATURE
Scale : 1:100
Drawing Title:- FIRST FLOOR PLAN
Drawing No:- RS-6